

DRAWINGS LIST

- TM-1 TOPOGRAPHICAL MAP
- SP-1 SITE PLAN
- ST-1 SEPTIC TANK PROFILE
- ST-2 SEPTIC TANK PLAN
- PT-1 PUMP TANK PROFILE
- GW-1 GRAY WATER PROFILE
- GW-2 GRAY WATER PLAN
- SF-1 SAND FILTER PROFILE
- SF-2 SAND FILTER PLAN
- AS-1 AEROBIC SYSTEM PROFILE
- AS-2 AEROBIC SYSTEM PLAN
- OF-1 SURGE TANK
- LF-1 LEACH FIELD XS
- LF-2 LEACH FIELD PLAN
- LF-3 LEACH FIELD JUNCTION

- Notes:**
1. THE COPYRIGHT OF THIS DRAWING IS VESTED IN YOURSPEEDHEADS, AND IT MAY NOT BE REPRODUCED IN WHOLE OR PART OR USED FOR THE MANUFACTURE OF ANY ARTICLE WITHOUT THE EXPRESS PERMISSION OF THE COPYRIGHT HOLDERS.
 2. WORK TO FIGURED DIMENSIONS ONLY.
 3. THIS DRAWING IS TO BE READ IN CONJUNCTION WITH ALL RELEVANT ARCHITECT'S SERVICE ENGINEERS AND YOURSPEEDHEADS DRAWINGS AND SPECIFICATIONS.

REV.	DESCRIPTION:	BY:	DATE:
	Drawing		

ABCC PROJECTS
2112 S. Huffer Ln
Flagstaff, AZ 86011
www.cefas.nau.edu/
copstone/projects/CENIE/
2022/Dewey/Septic/


CLIENT:
Taylor Layland
11800 Prescott Dells Ranch Road
Dewey, AZ

ARCHITECT:
ABCC Projects
2112 S.Huffer Lane
Flagstaff, AZ

SITE:
11800 Prescott Dells
Ranch Road, Dewey, AZ

TITLE:
Alternative Septic System
With Water Reuse

SCALE AT A2:	DATE:	DRAWN:	CHECKED:
N/A	12/12/2022	Cooper	N/A
PROJECT NO:	DRAWING NO:	REVISION:	
001	Cover Sheet	D	

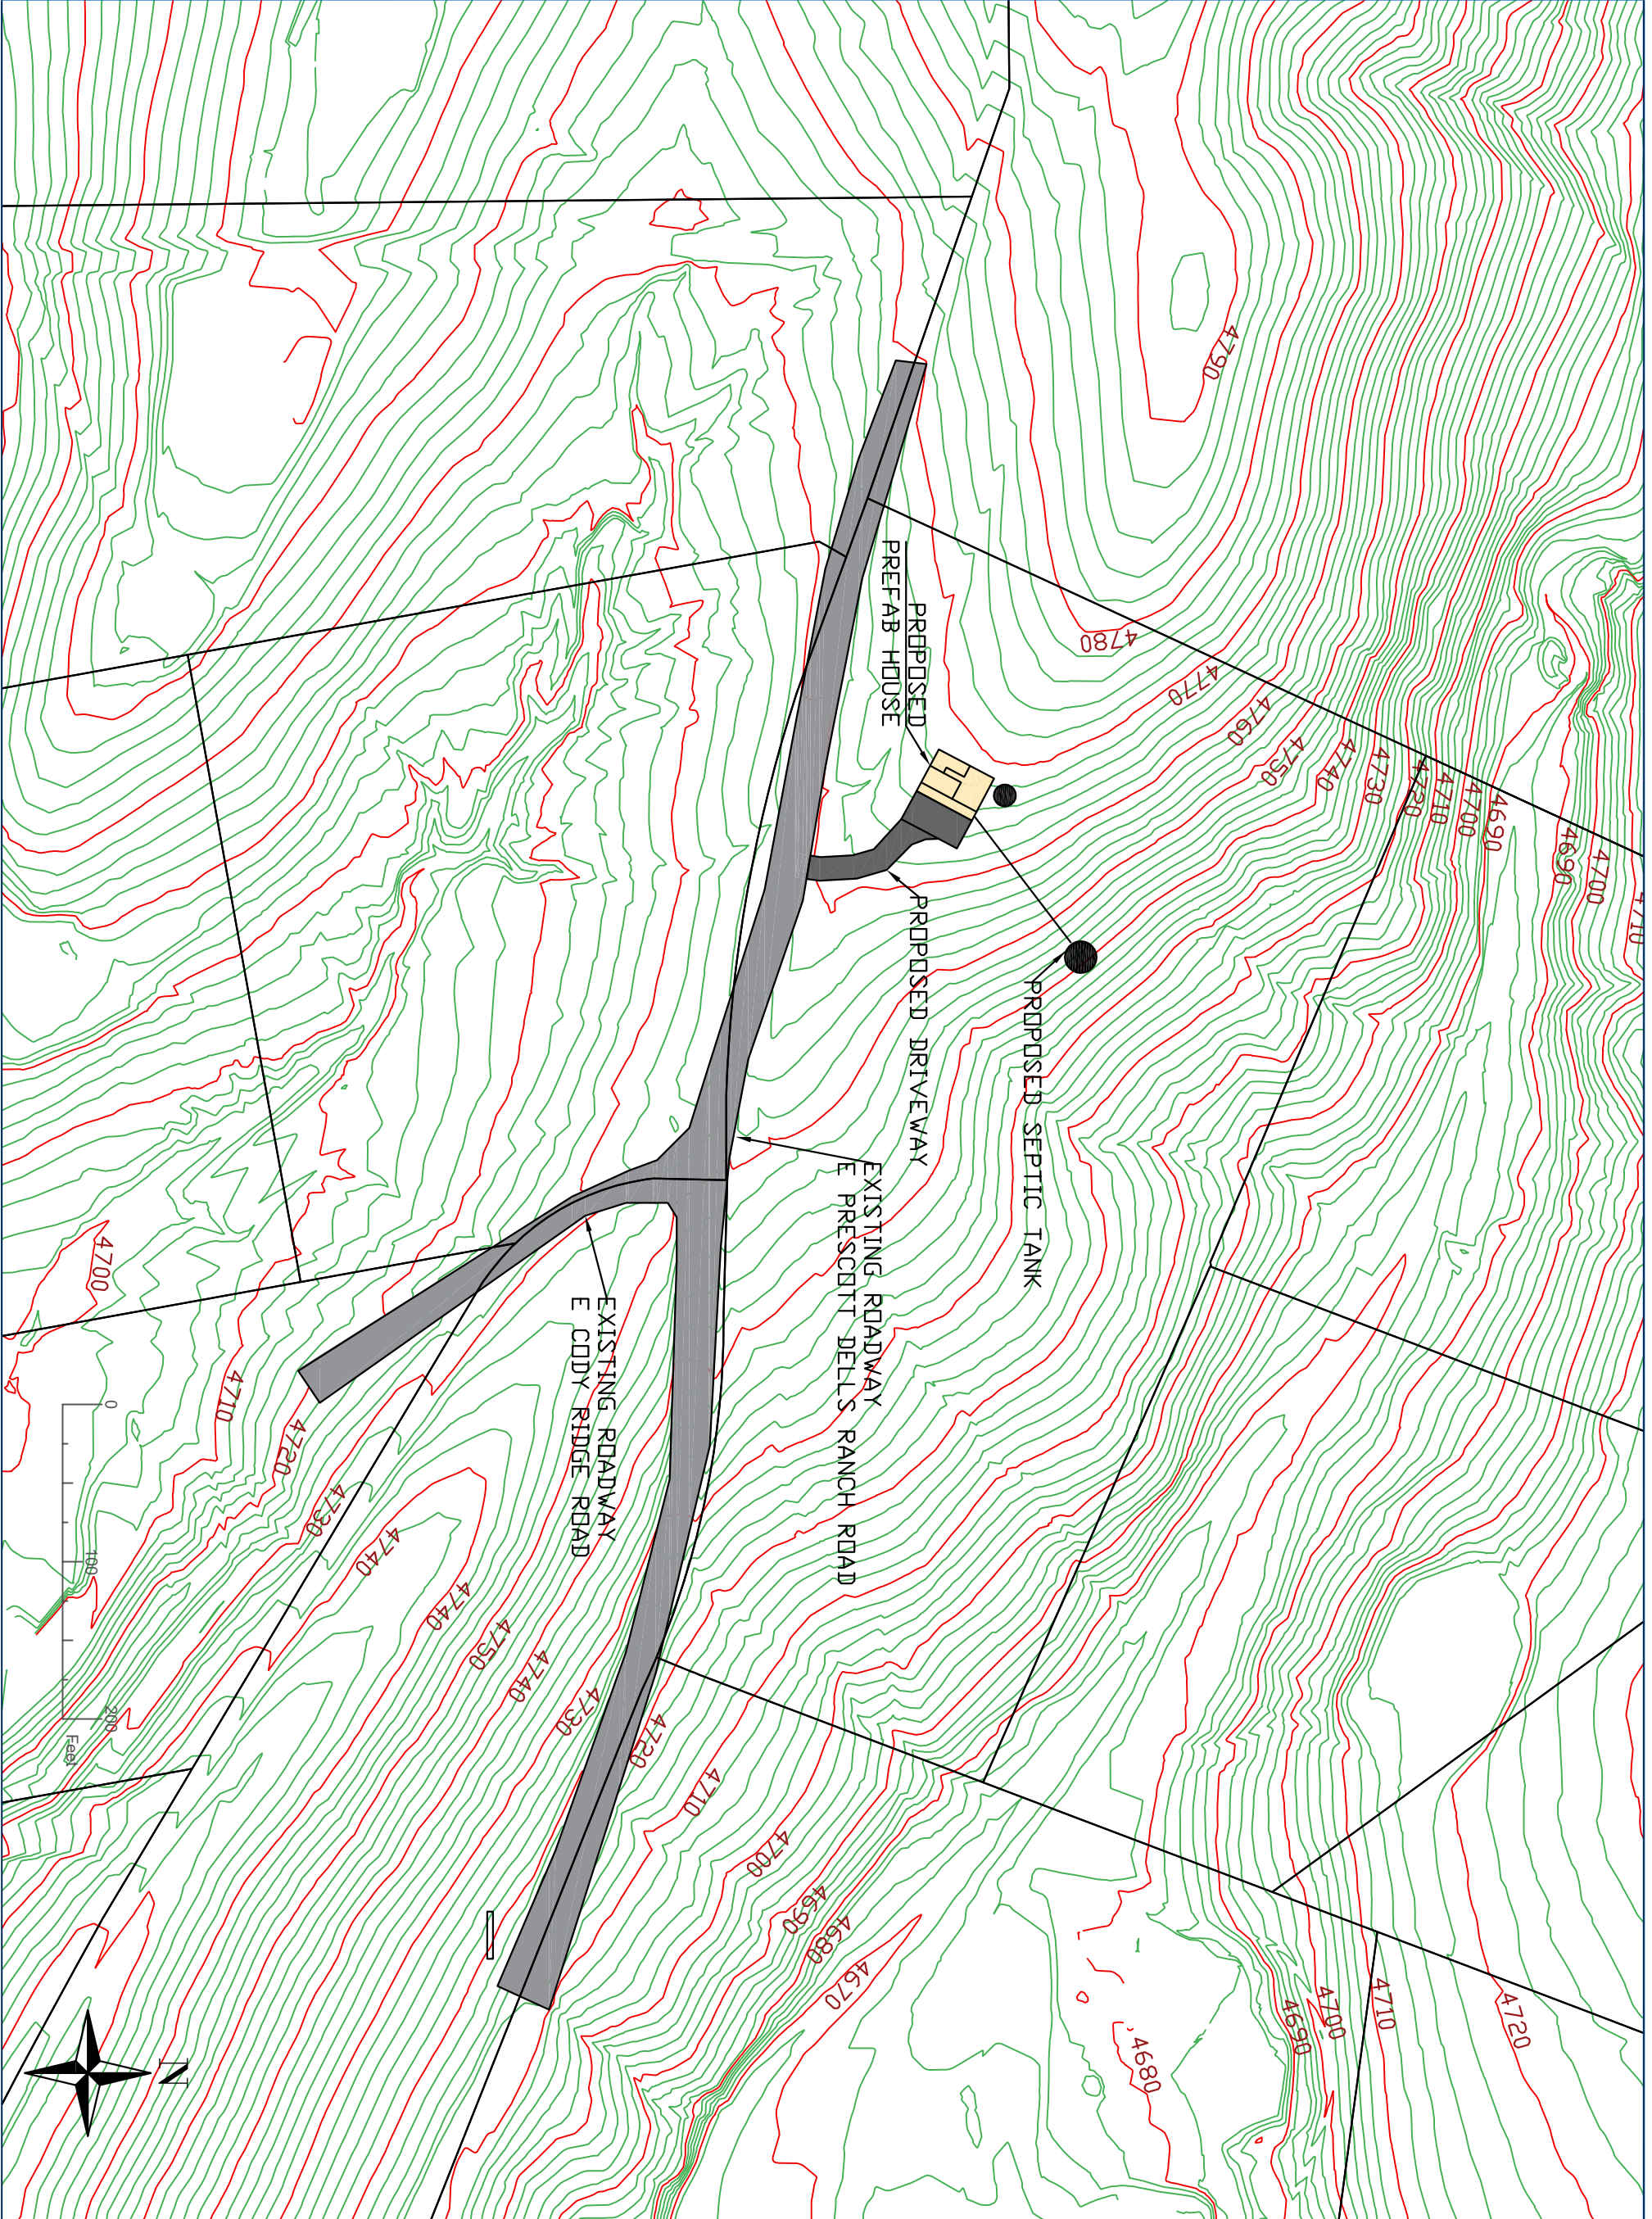

Notes:

1. THE COPYRIGHT OF THIS DRAWING IS VESTED IN YOURSPOONSHIRT AND IT MAY NOT BE REPRODUCED IN WHOLE OR PART OR USED FOR THE MANUFACTURE OF ANY ARTICLE WITHOUT THE EXPRESS PERMISSION OF THE COPYRIGHT HOLDERS.
2. WORK TO FIGURED DIMENSIONS ONLY.
3. THIS DRAWING IS TO BE READ IN CONJUNCTION WITH ALL RELEVANT ARCHITECT'S SERVICE ENGINEERS AND YOURSPOONSHIRT'S DRAWINGS AND SPECIFICATIONS.

REV.	DESCRIPTION	BY:	DATE:
	Drawing		

ABCC PROJECTS
 2112 S Huffer Ln
 Flagstaff, AZ 86011
www.abcc.com
customerservice@abcc.com
 2022/DeweySeptic/


CLIENT:
 Taylor Layland
 11800 Prescott Dells Ranch Road
 Dewey, AZ

ARCHITECT:
 ABCC Projects
 2112 S Huffer Lane
 Flagstaff, AZ

SITE:
 11800 Prescott Dells
 Ranch Road, Dewey, AZ

TITLE:
 Alternative Septic System
 With Water Reuse

SCALE AT AS:	DATE:	DRAWN:	CHECKED:
1:100	12/12/2022	Ron	Cooper
PROJECT NO.:	DRAWING NO.:	REVISION:	
001	TM-1		D

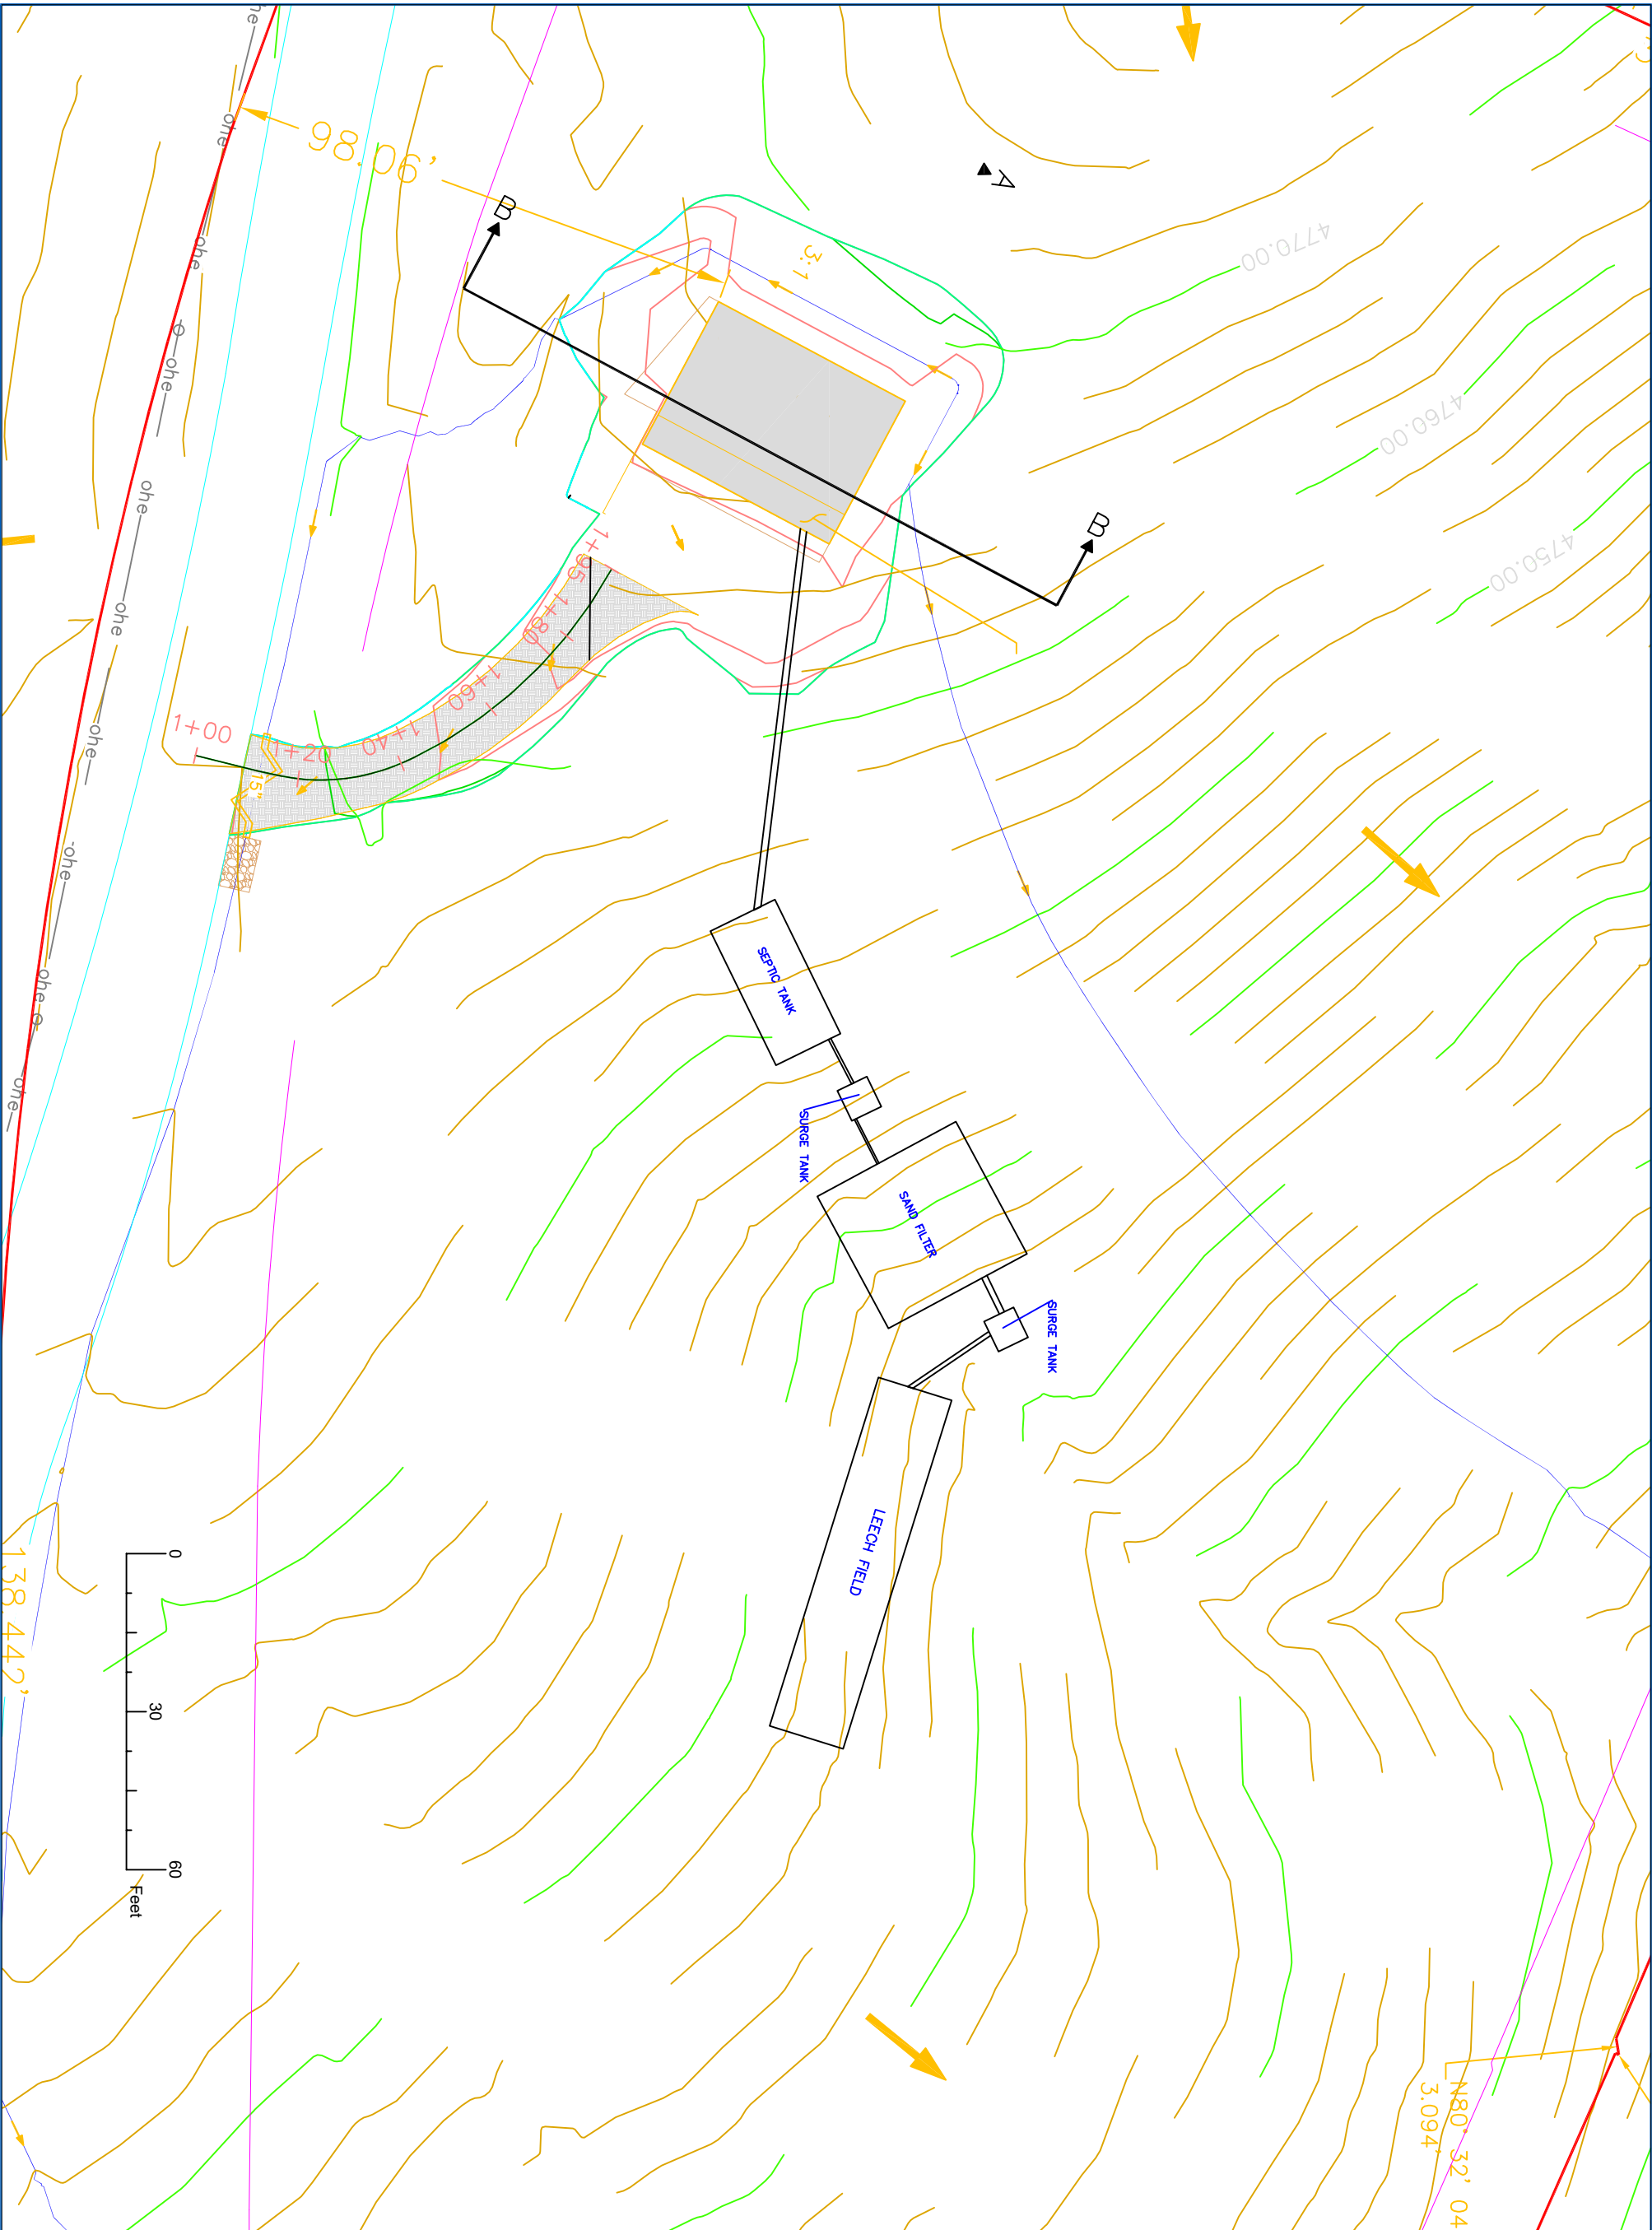


Notes:

1. THE COPYRIGHT OF THIS DRAWING IS VESTED IN YOURSPEAKERS AND IT MAY NOT BE REPRODUCED IN WHOLE OR PART OR USED FOR THE MANUFACTURE OF ANY ARTICLE WITHOUT THE EXPRESS PERMISSION OF THE COPYRIGHT HOLDERS.
2. WORK TO FIGURED DIMENSIONS ONLY.
3. THIS DRAWING IS TO BE READ IN CONJUNCTION WITH ALL RELEVANT ARCHITECT'S SERVICE ENGINEERS AND YOURSPEAKERS DRAWINGS AND SPECIFICATIONS.

REV. DESCRIPTION: Drawing		BY: DATE:
ABCC PROJECTS 2112 S. Hurfer Ln Flagstaff, AZ 86011 www.celistsneu.edu/ copstone/projects/CENE/ 2022/Dewey/Septic/		
CLIENT: Taylor Layland 11800 Prescott Dells Ranch Road Dewey, AZ		
ARCHITECT: ABCC Projects 2112 S. Hurfer Lane Flagstaff, AZ		
SITE: 11800 Prescott Dells Ranch Road, Dewey, AZ Alternative Septic System With Water Reuse		
SCALE AT 7/32 1:30		
PROJECT NO. 001	DATE: 12/12/2022	DRAWN: Henri
DRAWING NO. SP-1	CHECKED: Cooper	REVISION: D

- Notes:**
1. THE COPYRIGHT OF THIS DRAWING IS VESTED IN YOURSPROJECTS AND IT MAY NOT BE REPRODUCED IN WHOLE OR PART OR USED FOR THE MANUFACTURE OF ANY ARTICLE WITHOUT THE EXPRESS PERMISSION OF THE COPYRIGHT HOLDERS.
 2. WORK TO FIGURED DIMENSIONS ONLY.
 3. THIS DRAWING IS TO BE READ IN CONJUNCTION WITH ALL RELEVANT APPLICABLE SPACE ENGINEERING AND YOURSPROJECTS DRAWINGS AND SPECIFICATIONS.

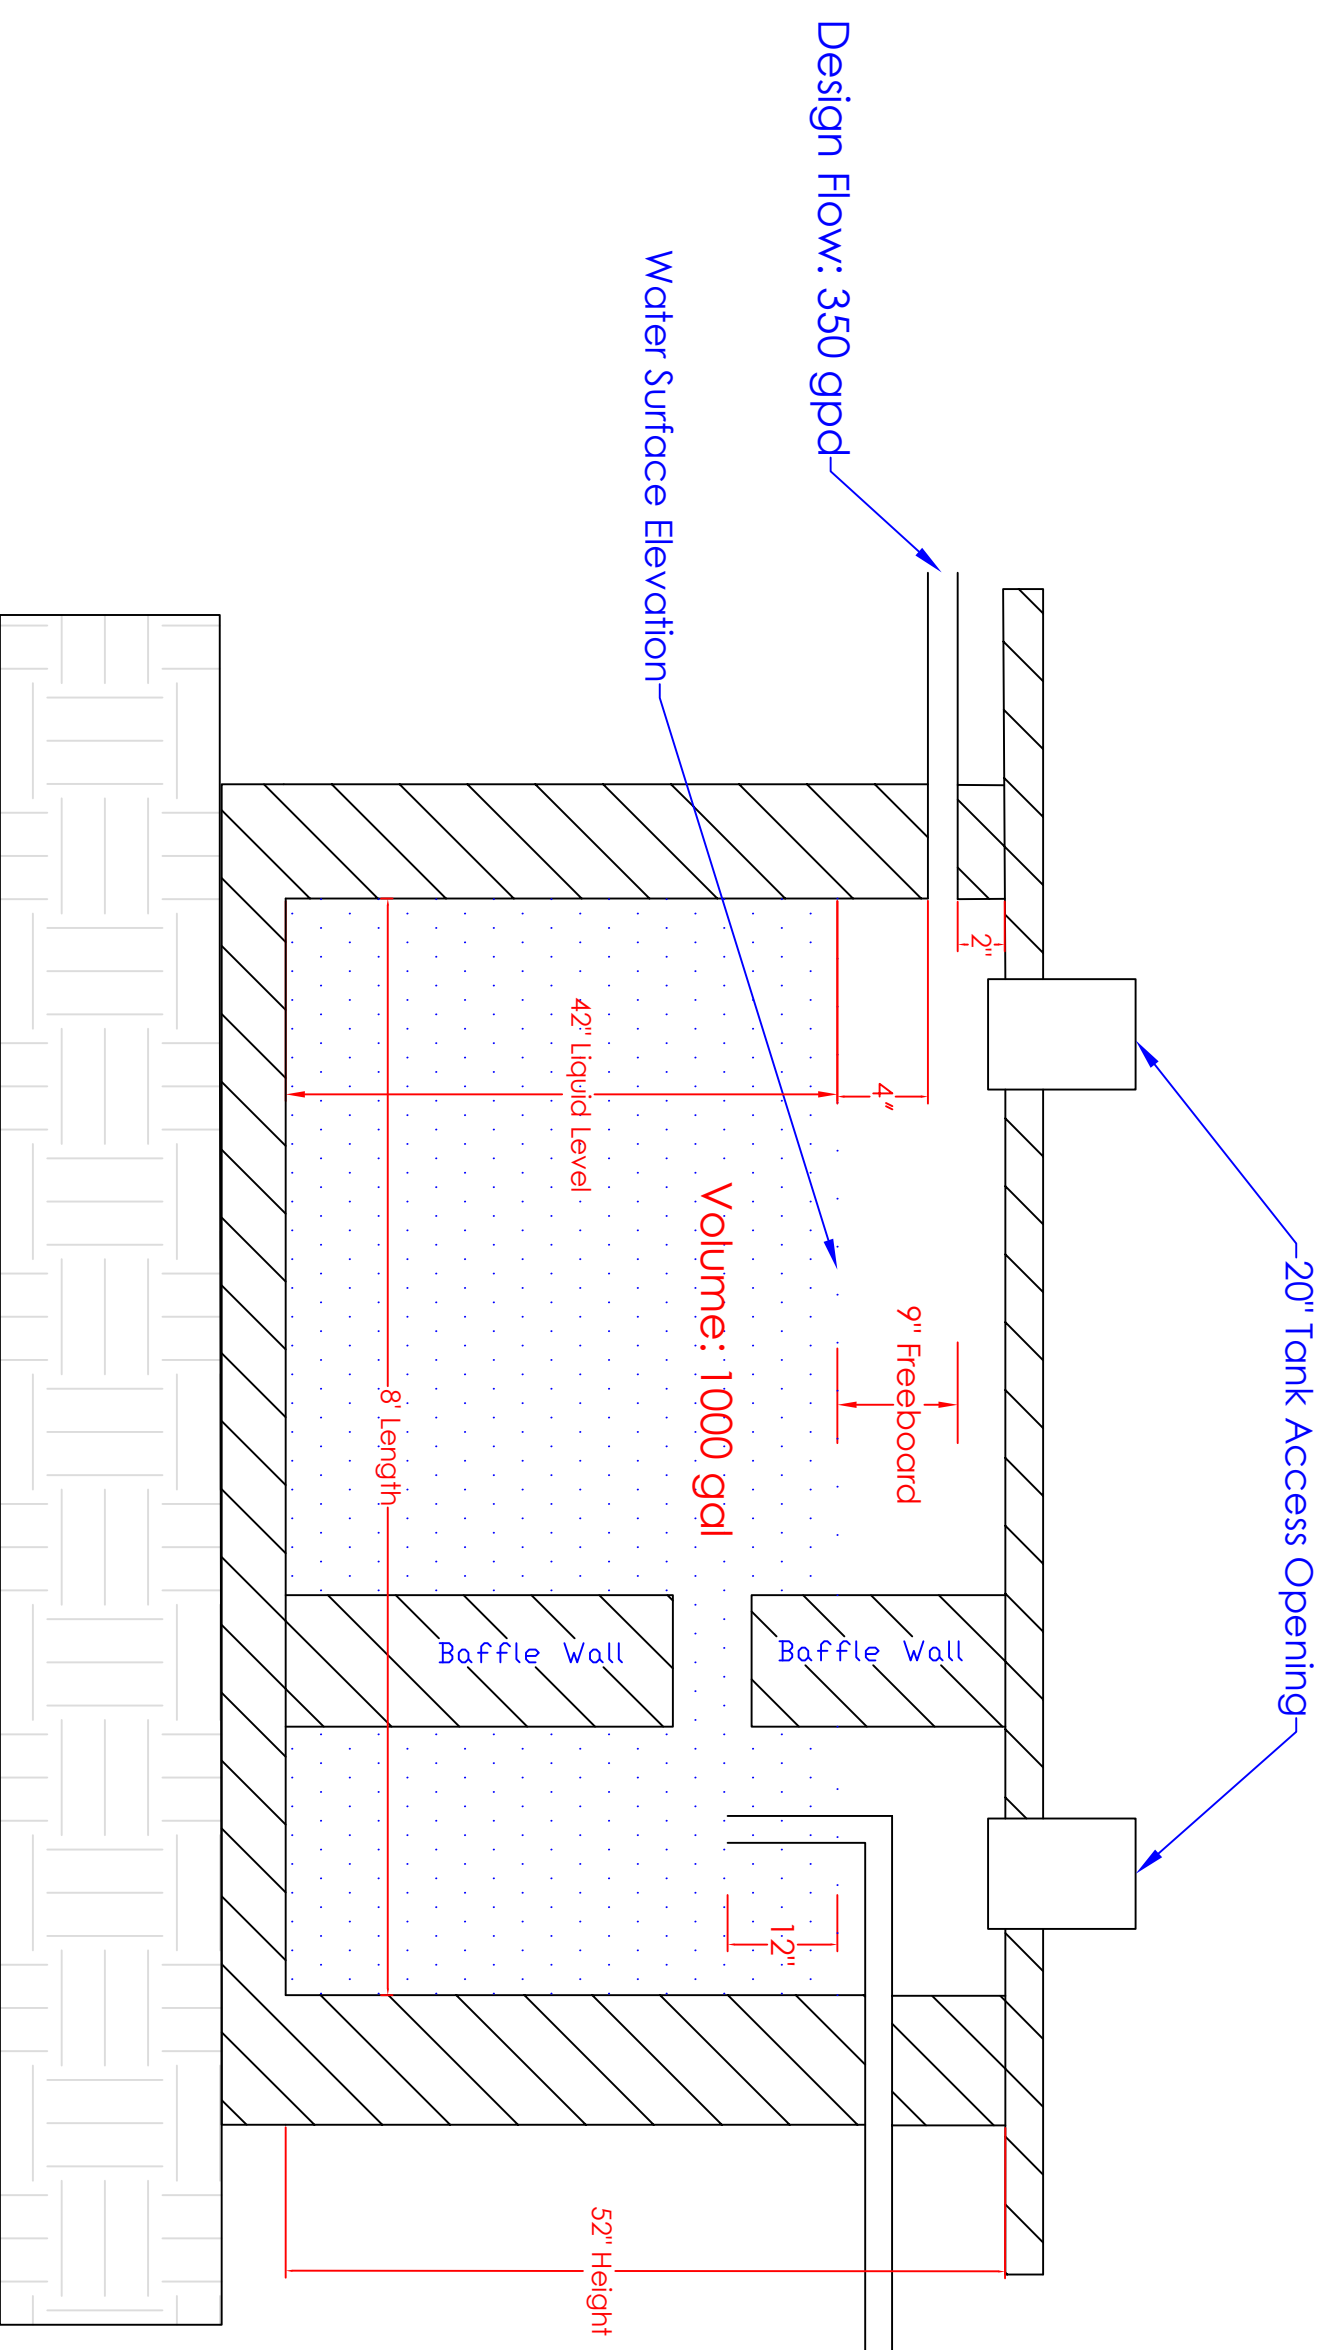

REV.	DESCRIPTION	BY	DATE
	Drawing		

ABCC PROJECTS
 2112 S Huffer Ln
 Flagstaff, AZ 86011
 www.cejcs.nyu.edu/
 ccapstone/projects/CENE/
 2022/DeweySeptic/

CLIENT:
 Taylor Layland
 11800 Prescott Delis Ranch Road
 Dewey, AZ



ARCHITECT:
 ABCC Projects
 2112 S Huffer Lane
 Flagstaff, AZ

SITE:
 11800 Prescott Delis
 Ranch Road, Dewey, AZ

TITLE:
 Alternative Septic System
 With Water Reuse

SCALE AT A2:	DATE:	DRAWN:	CHECKED:
1:5	12/12/2022	Hentl	Cooper
PROJECT NO:	DRAWING NO:	REVISION:	
001	ST-1	D	

 - Notes:**
1. THE COPYRIGHT OF THIS DRAWING IS VESTED IN YOURSPEAKERSHOP AND IT MAY NOT BE REPRODUCED IN WHOLE OR PART OR USED FOR THE MANUFACTURE OF ANY ARTICLE WITHOUT THE EXPRESS PERMISSION OF THE COPYRIGHT HOLDERS.
 2. WORK TO FIGURED DIMENSIONS ONLY.
 3. THIS DRAWING IS TO BE READ IN CONJUNCTION WITH ALL RELEVANT ARCHITECT'S SERVICE ENGINEERS AND YOURSPEAKERSHOP DRAWINGS AND SPECIFICATIONS.

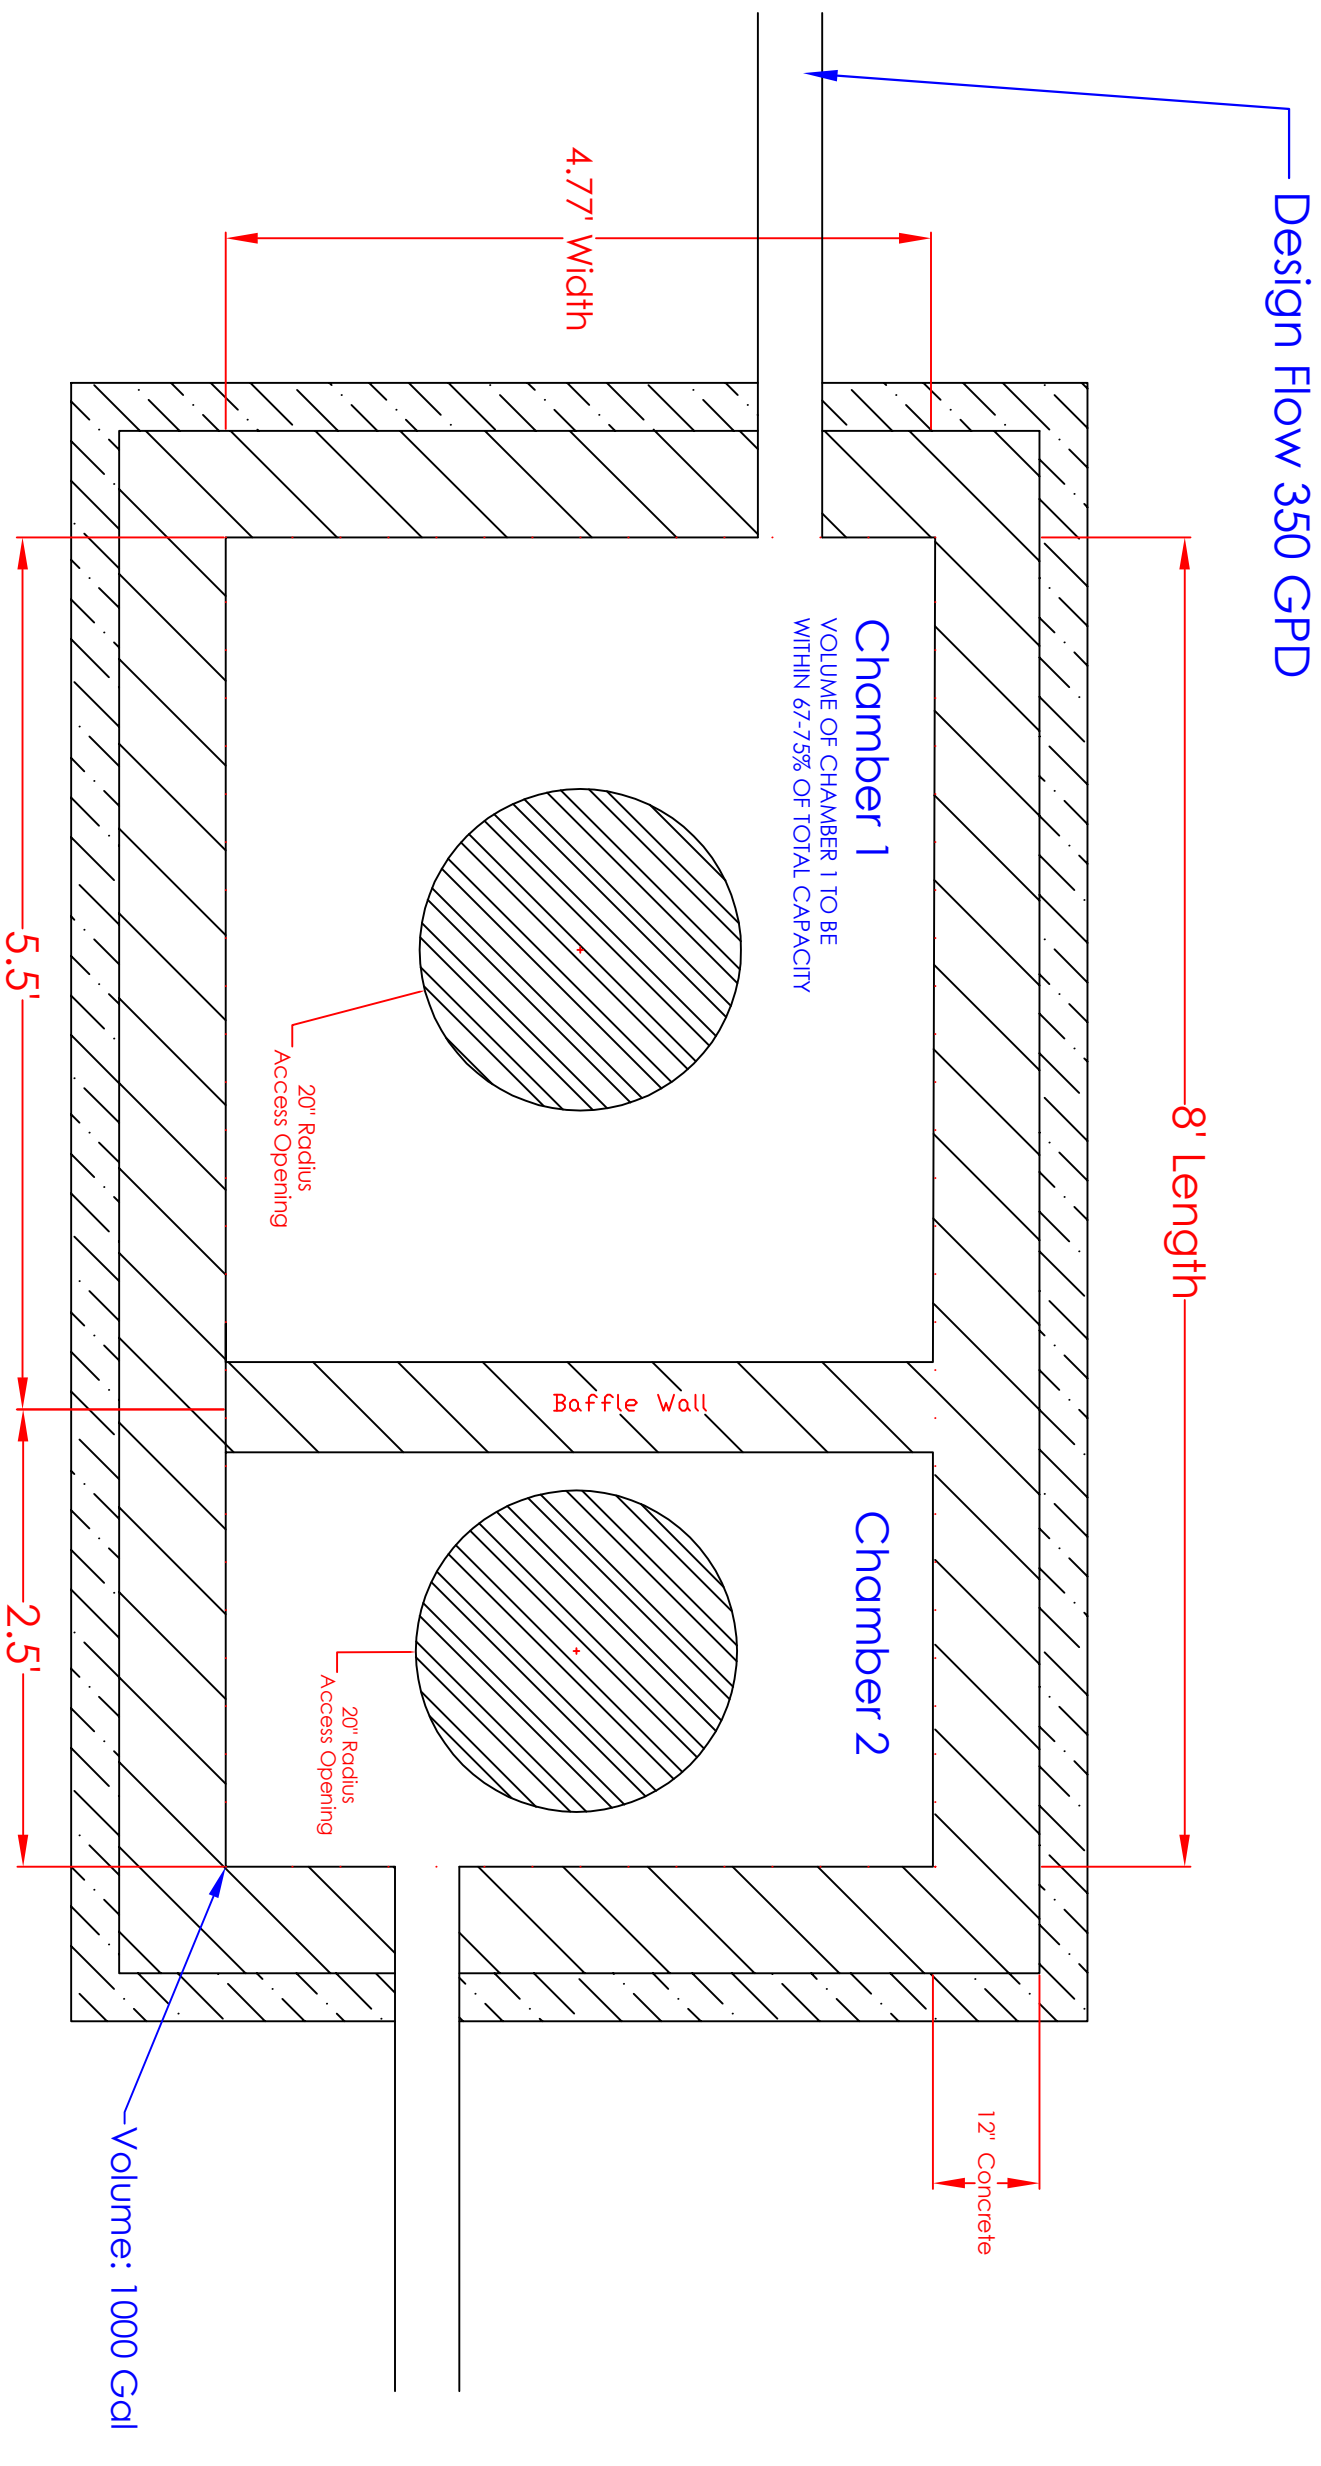

REV.	DESCRIPTION:	BY:	DATE:
	Drawing		

ABCC PROJECTS
 2112 S. Huffer Ln
 Flagstaff, AZ 86011
 www.celists.nou.edu/
 copstone/projects/CENE/
 2022/Dewey/Septic/

CLIENT:
 Taylor Layland
 11800 Prescott Dells Ranch Road
 Dewey, AZ

ARCHITECT:
 ABCC Projects
 2112 S.Huffer Lane
 Flagstaff, AZ



SITE:
 11800 Prescott Dells
 Ranch Road, Dewey, AZ

TITLE:
 Alternative Septic System
 With Water Reuse

SCALE AT ASZ	DATE:	DRAWN:	CHECKED:
1:6	12/12/2022	Hentl	Cooper
PROJECT NO:	DRAWING NO:	REVISION:	
001	ST-2		D



Notes:

 1. THE COPYRIGHT OF THIS DRAWING IS VESTED IN YOURSPEEDHEAD AND IT MAY NOT BE REPRODUCED IN WHOLE OR PART OR USED FOR THE MANUFACTURE OF ANY ARTICLE WITHOUT THE EXPRESS PERMISSION OF THE COPYRIGHT HOLDERS.
2. WORK TO FIGURED DIMENSIONS ONLY.
3. THIS DRAWING IS TO BE READ IN CONJUNCTION WITH ALL RELEVANT ARCHITECT'S SERVICE ENGINEERS AND YOURSPEEDHEAD DRAWINGS AND SPECIFICATIONS.

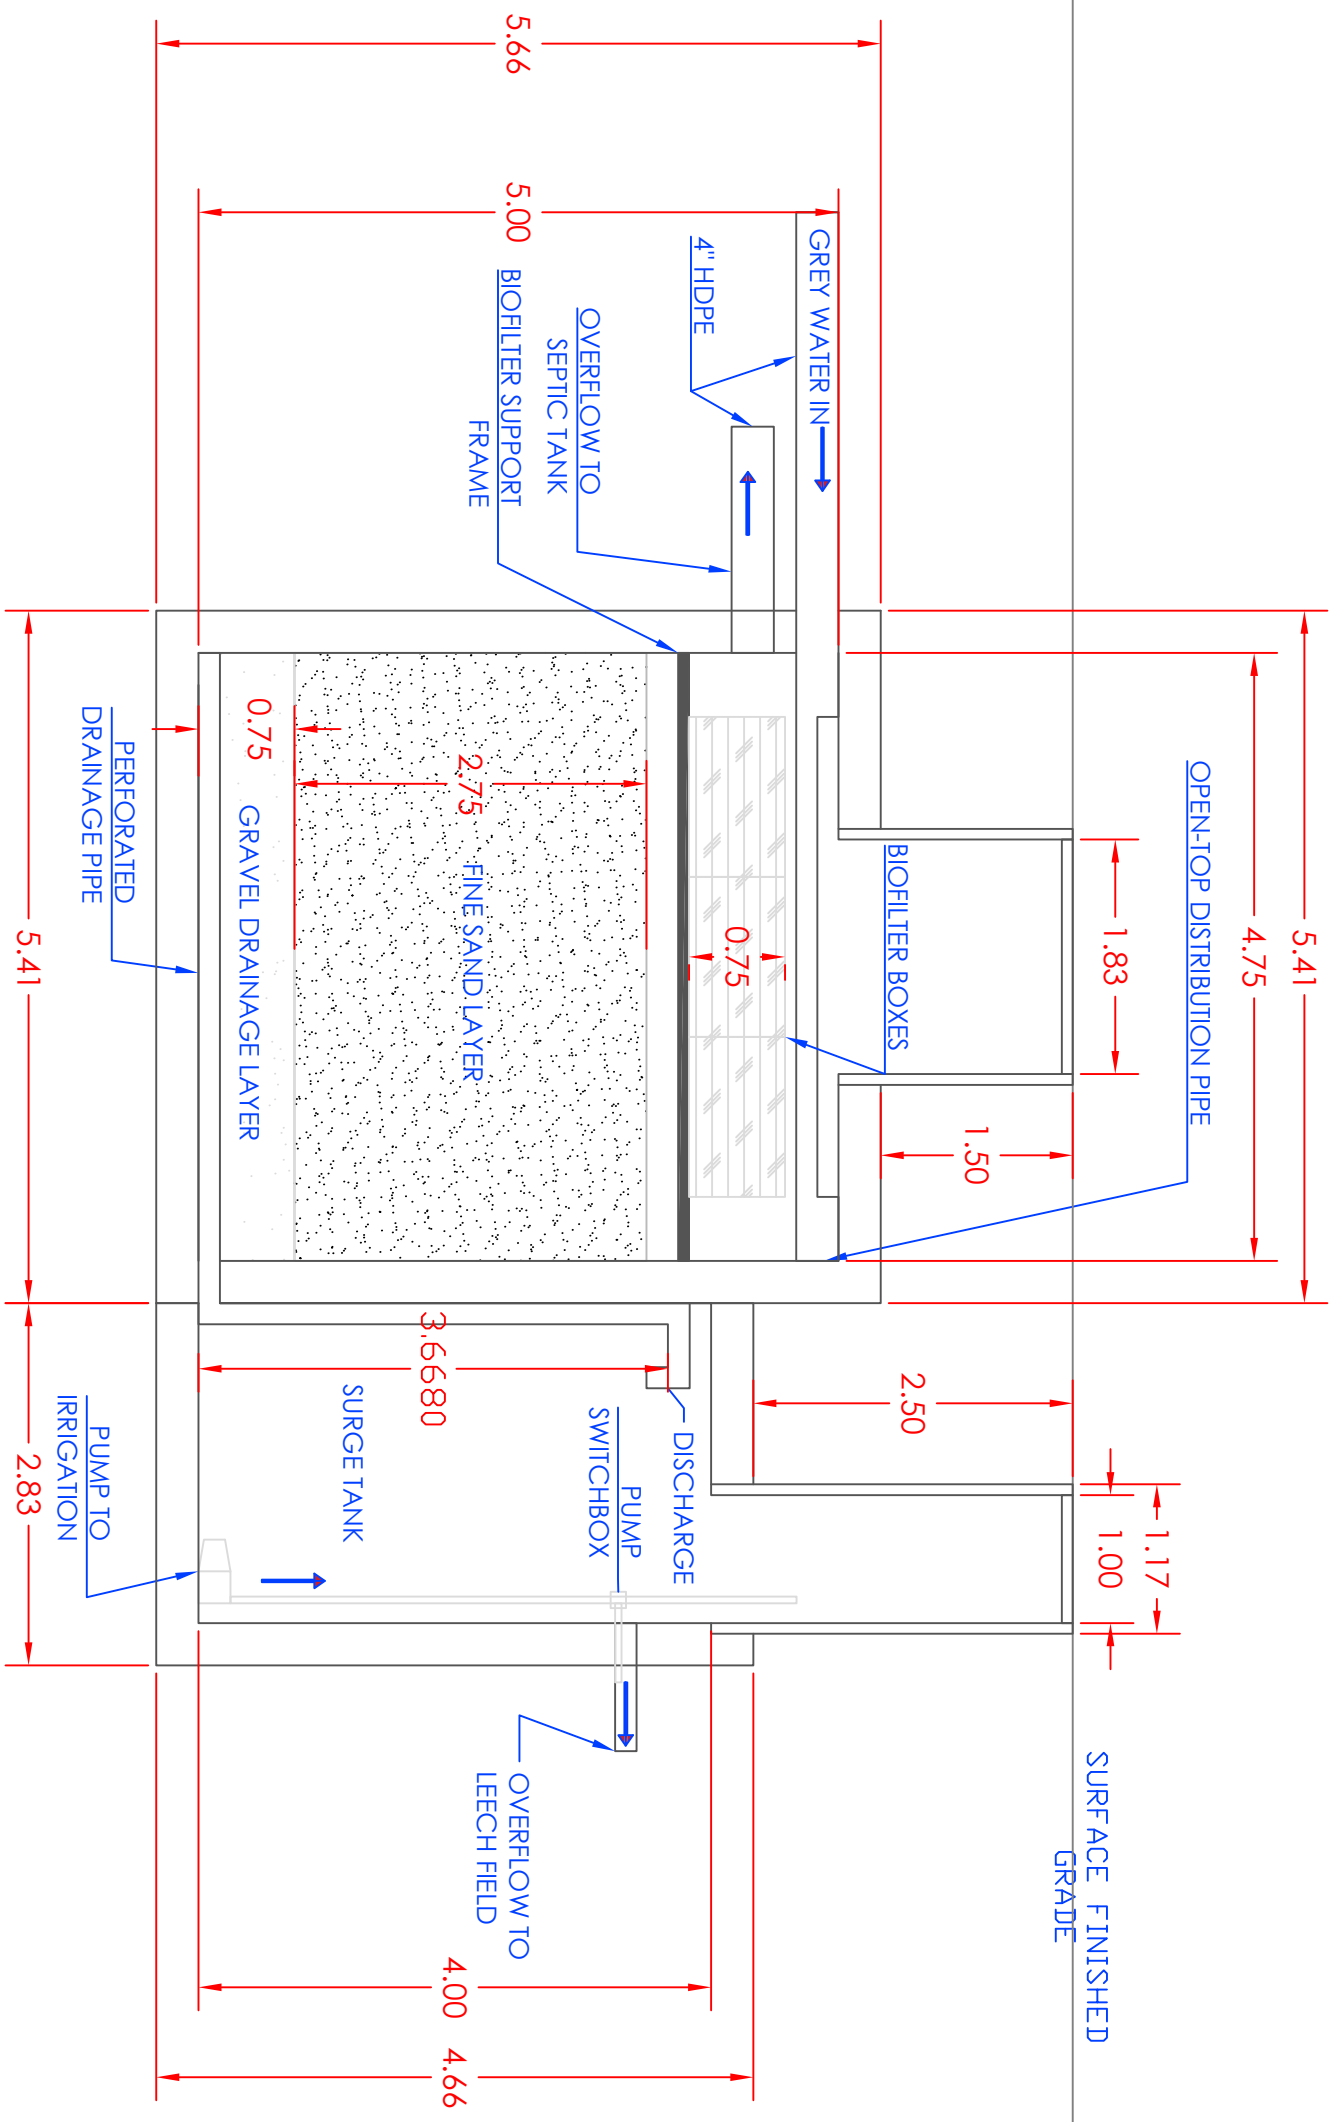

REV:	DESCRIPTION:	BY:	DATE:
STATUS:	Drawing		
ABCC PROJECTS 2112 S. Hurfer Ln Flagstaff, AZ 86011 www.abccsolutions.com/ copstone/projects/CENE/ 2022/Dewey/Septic/			
CLIENT:	Taylor Layland 11800 Prescott Dells Ranch Road Dewey, AZ		
ARCHITECT:	ABCC Projects 2112 S. Hurfer Lane Flagstaff, AZ		
SITE:	11800 Prescott Dells Ranch Road, Dewey, AZ		
TITLE:	Alternative Septic System With Water Reuse		
SCALE AT A2:	DATE:	DRAWN:	CHECKED:
1:1.5	12/12/2022	Ron	Cooper
PROJECT NO:	DRAWING NO:	REVISION:	
001	GW-1		D

 - Notes:**
1. THE COPYRIGHT OF THIS DRAWING IS VESTED IN YOURSPEAKERSHIP AND IT MAY NOT BE REPRODUCED IN WHOLE OR PART OR USED FOR THE MANUFACTURE OF ANY ARTICLE WITHOUT THE EXPRESS PERMISSION OF THE COPYRIGHT HOLDER.
 2. WORK TO REQUIRED DIMENSIONS ONLY.
 3. THIS DRAWING IS TO BE READ IN CONJUNCTION WITH ALL RELEVANT ARCHITECTS, SERVICE ENGINEERS AND YOURSPEAKERSHIP DRAWINGS AND SPECIFICATIONS.

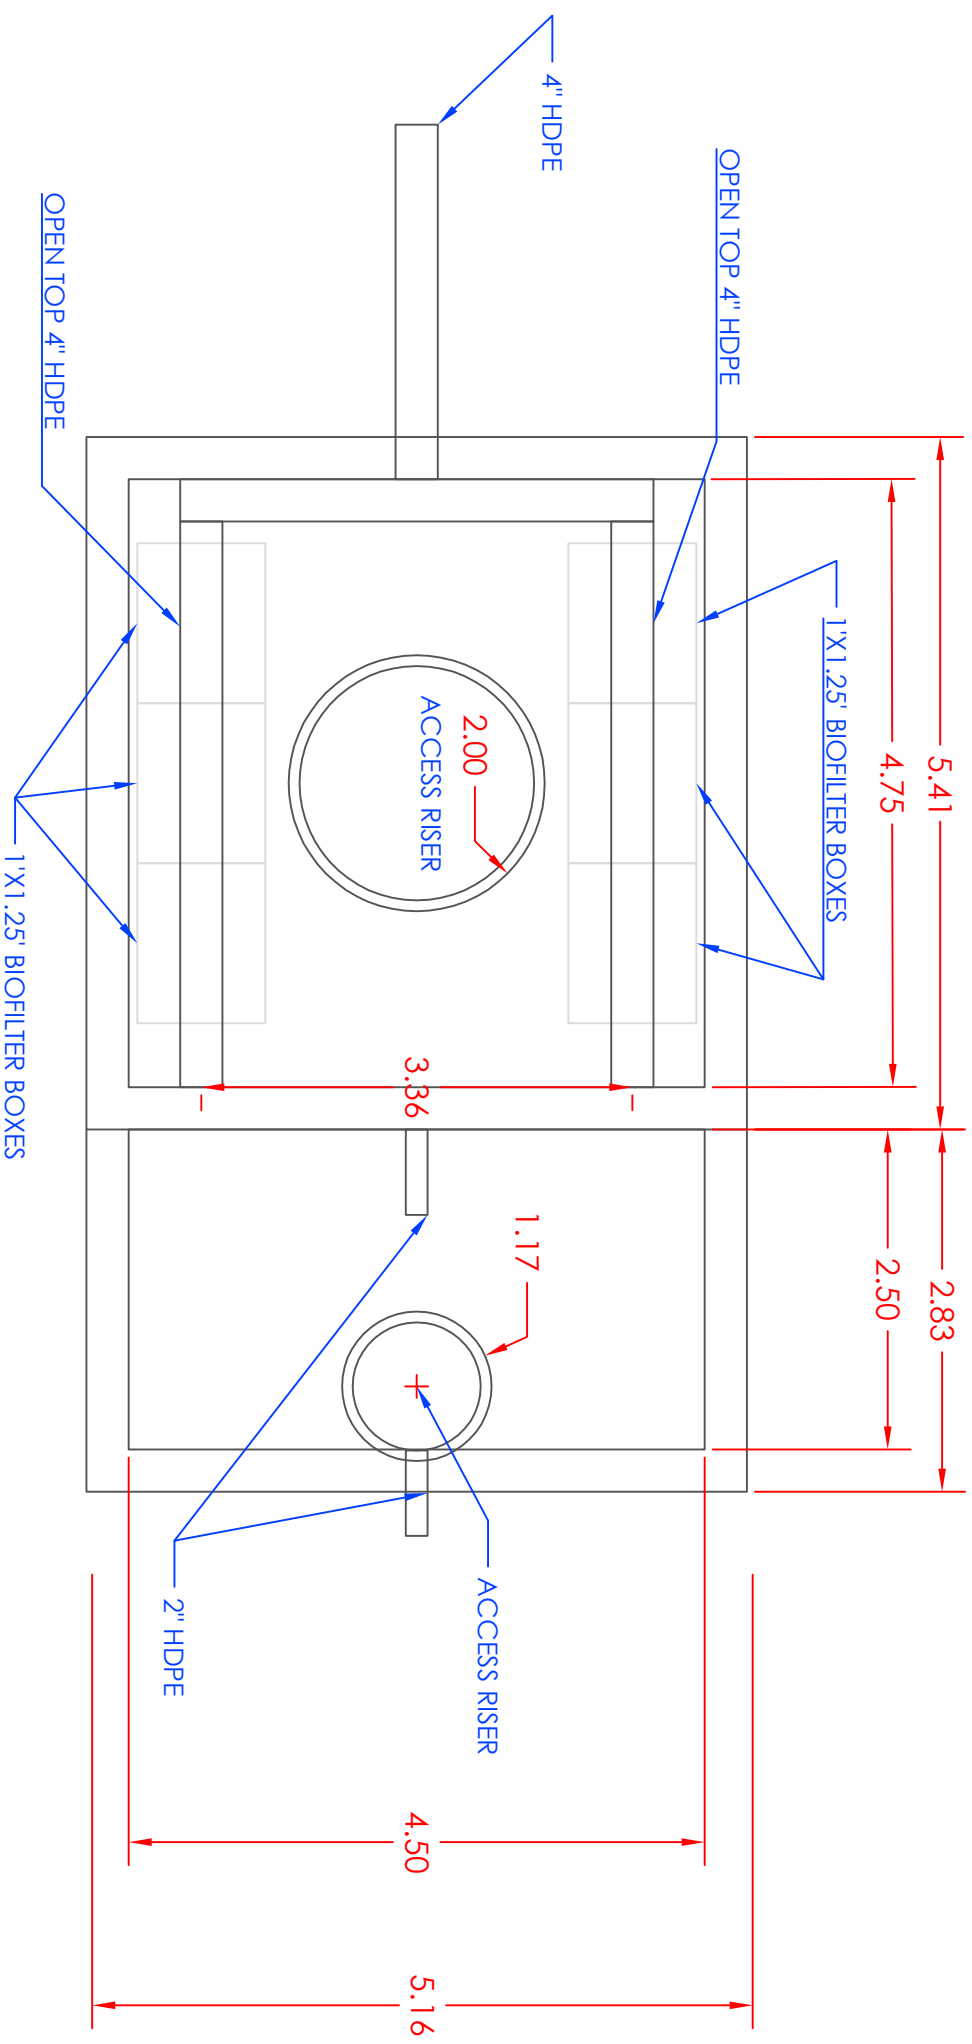

REV.	DESCRIPTION	BY	DATE
	Drawing		

ABCC PROJECTS
 2112 S. Huffer Ln.
 Flagstaff, AZ 86011
 www.celidsonu.edu/
 capstone/projects/CENE/
 2022/Dewey/septic/

CLIENT:
 Taylor Loyland
 11800 Prescott Dale Ranch Road
 Dewey, AZ

ARCHITECT:
 ABCC Projects
 2112 S. Huffer Lane
 Flagstaff, AZ


SITE:
 11800 Prescott Dells
 Ranch Road, Dewey, AZ

TITLE:
 Alternative Septic System
 With Water Reuse

SCALE AT A2	DATE	DRAWN	CHECKED
1:1.5	12/12/2022	Ron Cooper	Cooper
PROJECT NO.	DRAWING NO.	REVISION	
001	GW-2		D

Notes:

1. THE COPYRIGHT OF THIS DRAWING IS VESTED IN YOURSPEEDDRAFTS AND SHALL NOT BE REPRODUCED IN WHOLE OR IN PART OR USED FOR THE REPRODUCTION OF ANY AND ALL KINDS WITHOUT THE EXPRESS PERMISSION OF THE COPYRIGHT HOLDERS.
2. WORK TO FIGURED DIMENSIONS ONLY.
3. THIS DRAWING IS TO BE READ IN CONJUNCTION WITH ALL RELEVANT ARCHITECTS, SERVICE ENGINEERS AND YOURSPEEDDRAFTS DRAWINGS AND SPECIFICATIONS.

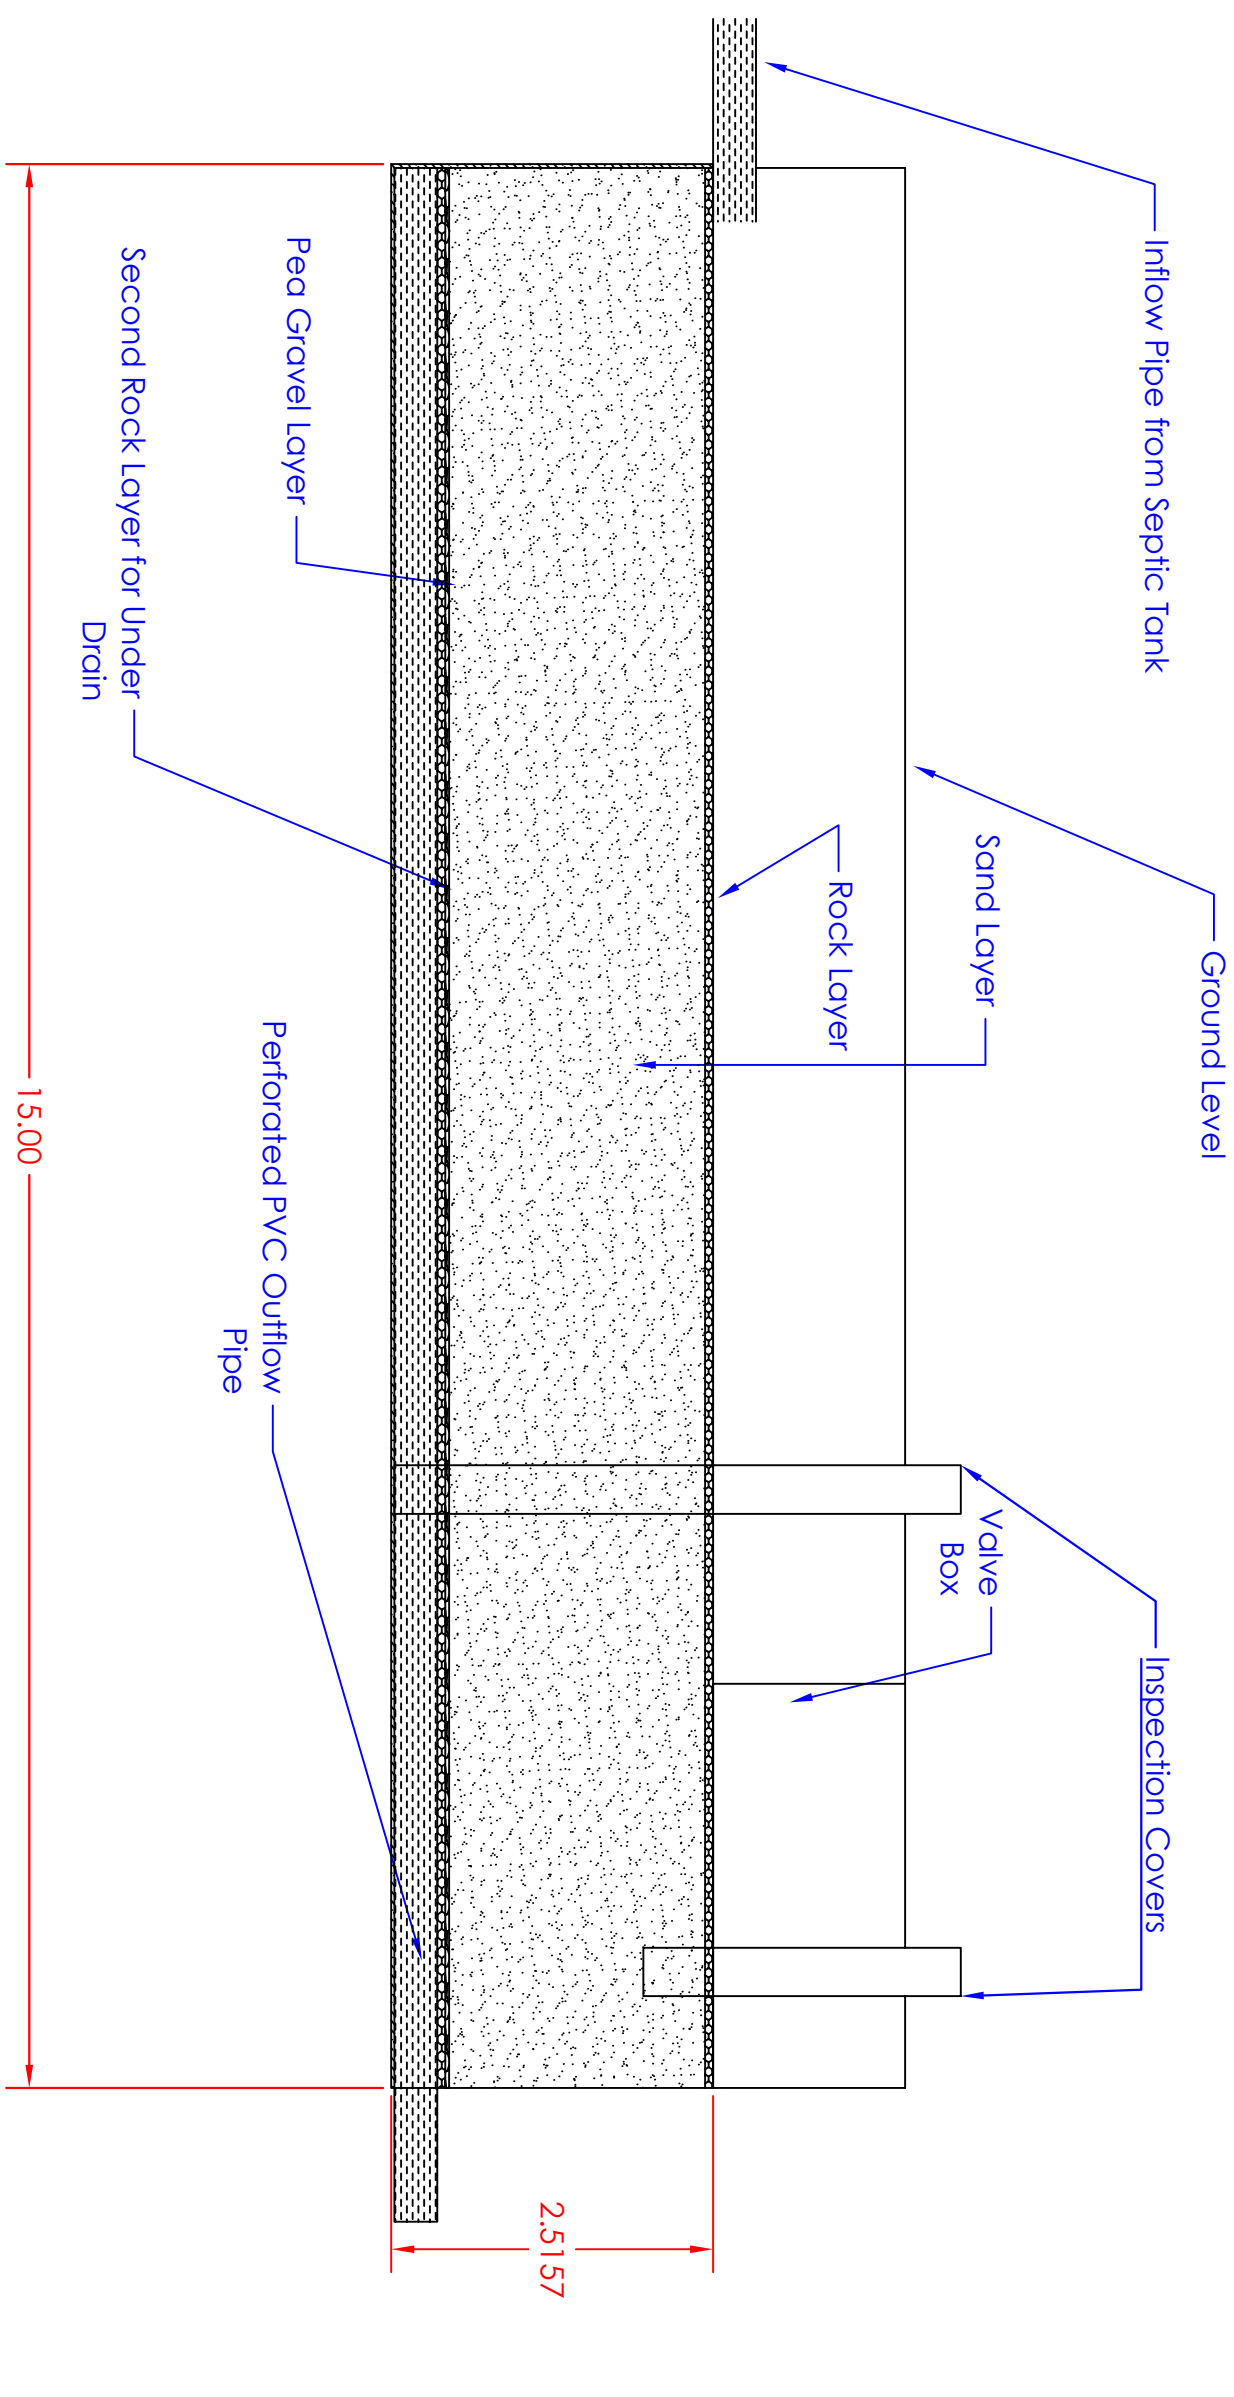

REV.	DESCRIPTION:	BY:	DATE:
	Drawing		

ABCC PROJECTS
 2112 S Hurter Ln
 Flagstaff, AZ 86011
 www.abccsolutions.com/
 capstone/projects/CENF/
 2022/Dewey/Septic/

CLIENT:
 Taylor Loyland
 11800 Prescott Delis Ranch Road
 Dewey, AZ

ARCHITECT:
 ABCC Projects
 2112 S Hurter Lane
 Flagstaff, AZ


SITE:
 11800 Prescott Delis
 Ranch Road, Dewey, AZ

TITLE:
 Alternative Septic System
 With Water Reuse

SCALE AT AZ:	DATE:	DRAWN:	CHECKED:
1:1.5	12/12/2022	Cooper	Hentl
PROJECT NO.:	DRAWING NO.:	REVISION:	
001	SF-1	D	

Notes:

1. THE COPYRIGHT OF THIS DRAWING IS VESTED IN YOURSPEAKERS, AND IT MAY NOT BE REPRODUCED IN WHOLE OR PART OR USED FOR THE MANUFACTURE OF ANY ARTICLE WITHOUT THE EXPRESS PERMISSION OF THE COPYRIGHT HOLDERS.
2. WORK TO FIGURED DIMENSIONS ONLY.
3. THIS DRAWING IS TO BE READ IN CONJUNCTION WITH ALL RELEVANT SPECS AND SERVICE ENGINEERS AND YOURSPEAKERS DRAWINGS AND SPECIFICATIONS.

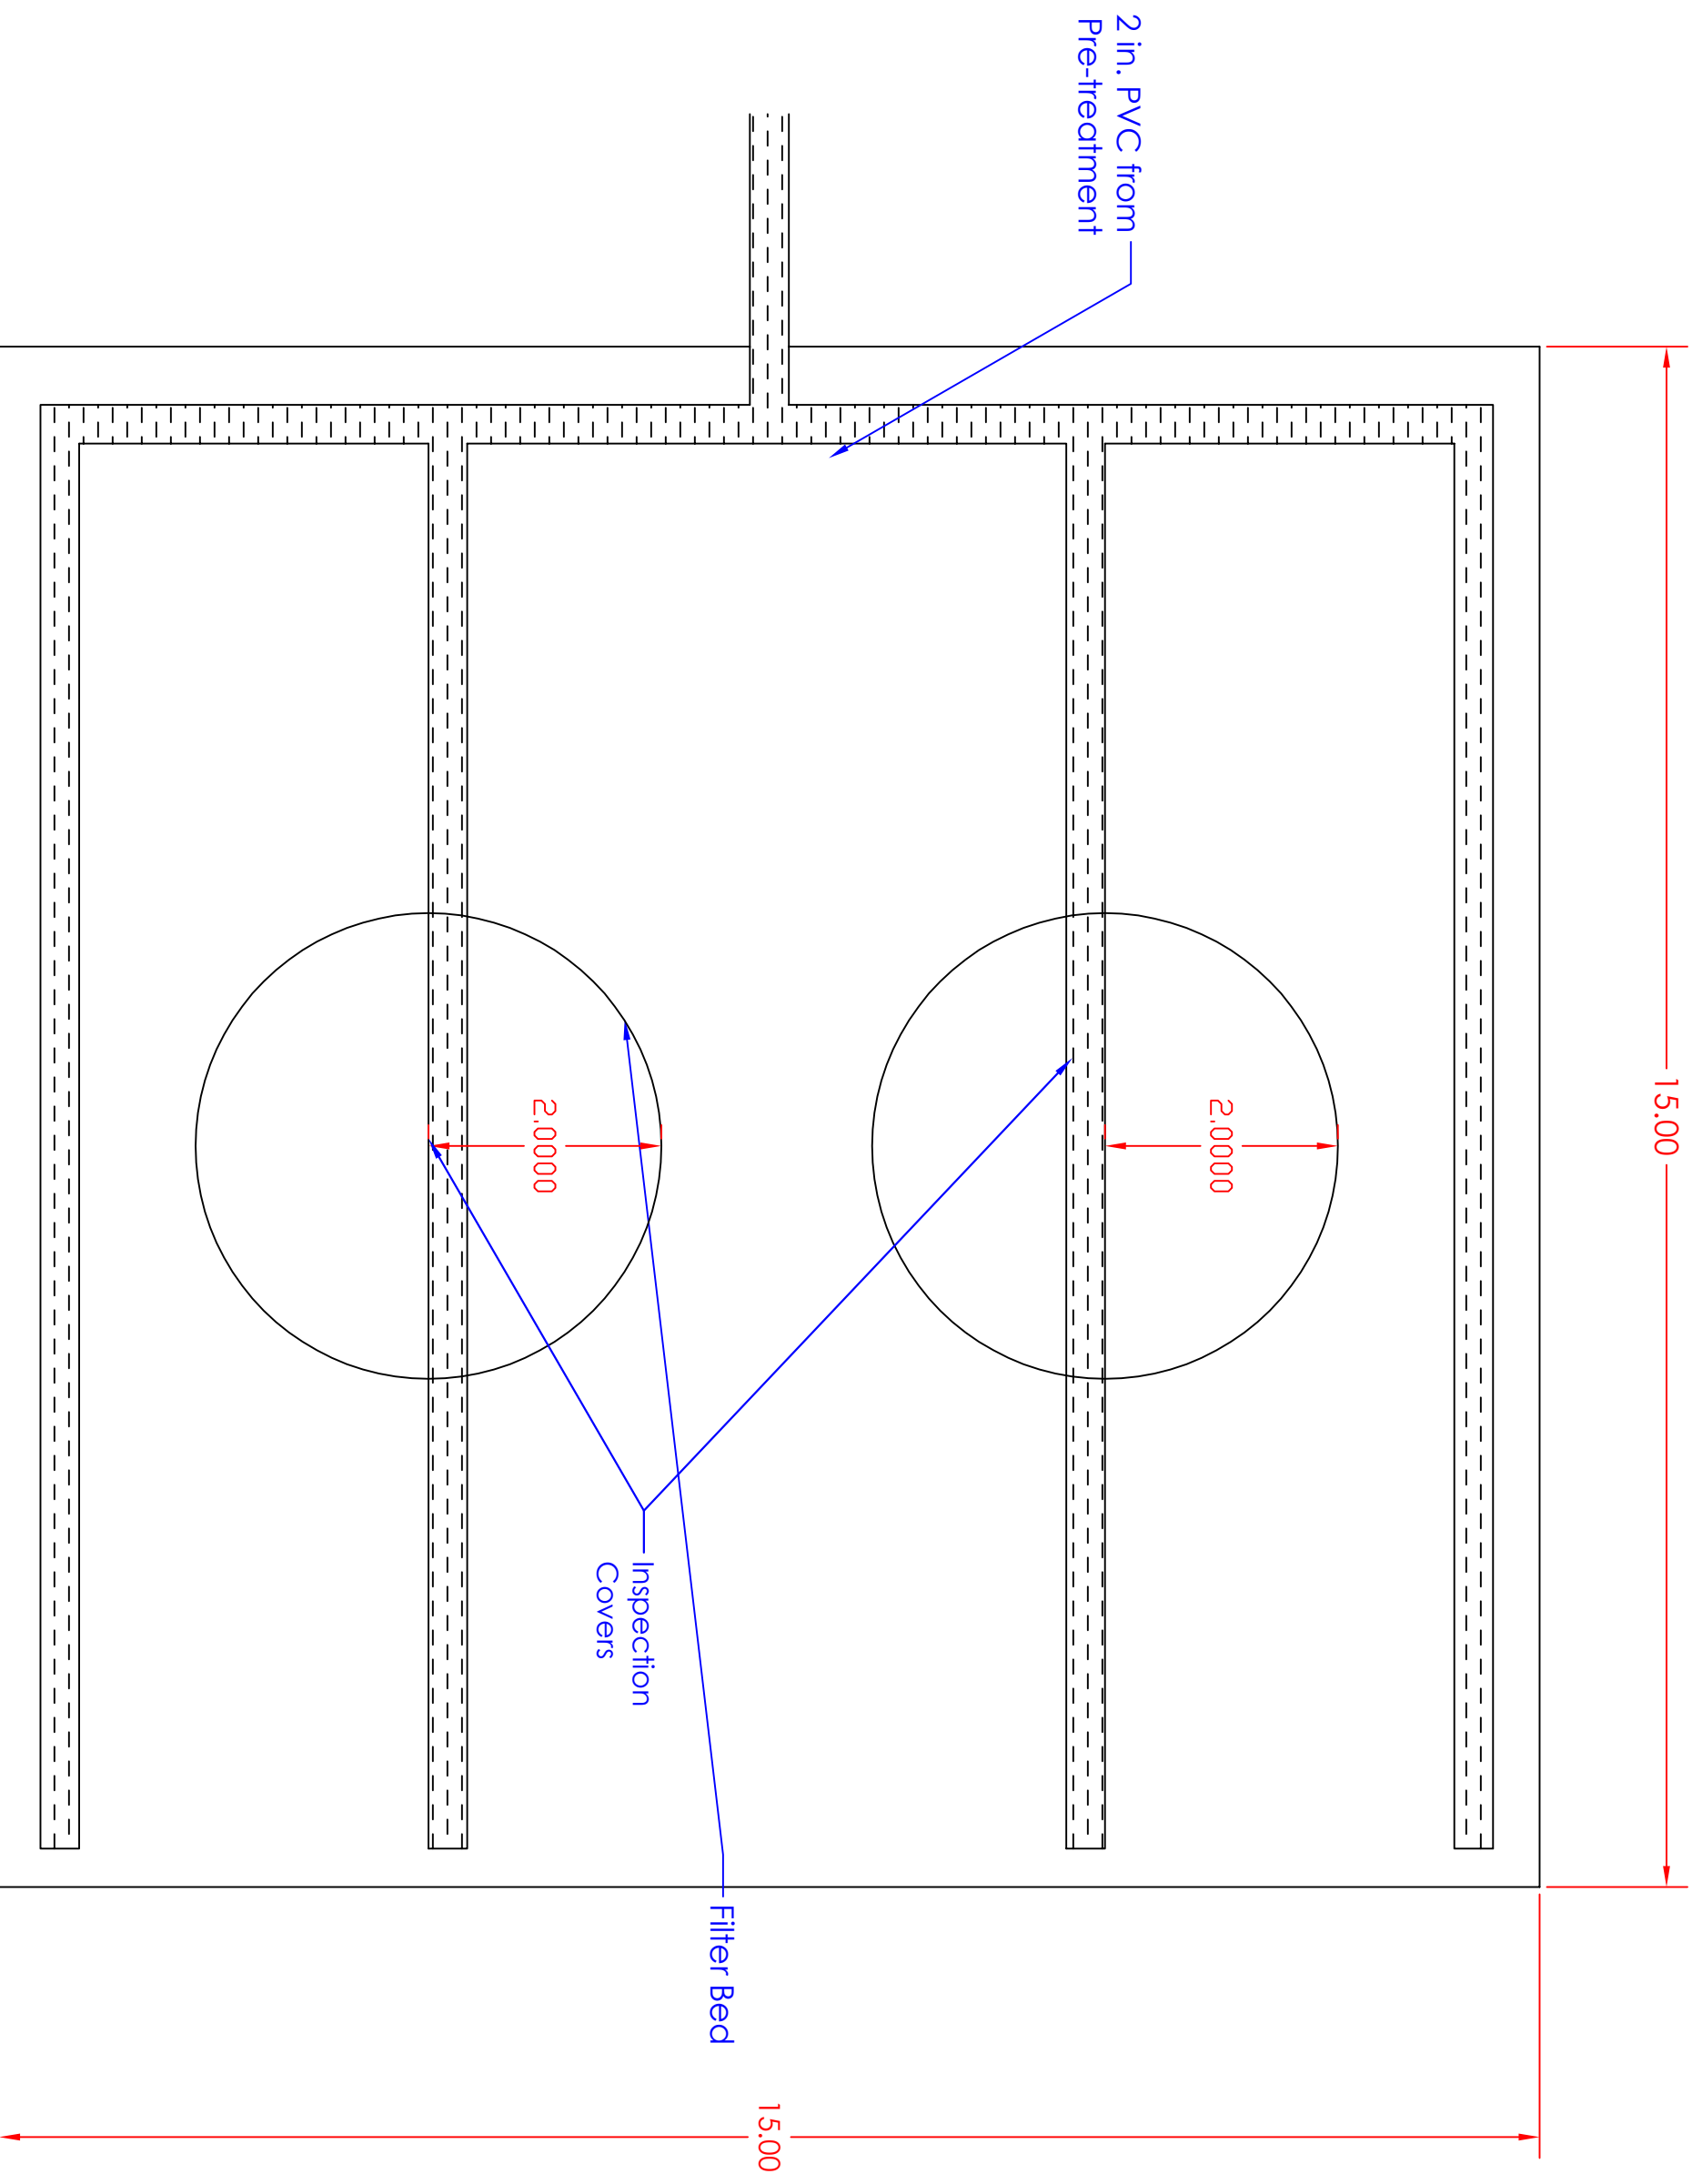

REV#	DESCRIPTION	BY	DATE
	Drawing		

ABCC PROJECTS
 2112 S Huffer Ln
 Flagstaff, AZ 86011
 www.abccprojects.com
 copstone/projects/CENM/
 2022/Dewey/Septic/


CLIENT:
 Taylor Layland
 11800 Prescott Dells Ranch Road
 Dewey, AZ

ARCHITECT:
 ABCC Projects
 2112 S Huffer Lane
 Flagstaff, AZ

SITE:
 11800 Prescott Dells
 Ranch Road, Dewey, AZ
**Alternative Septic System
 With Water Reuse**

PROJECT NO.	DATE	DRAWN	CHECKED
001	12/12/2022	Cooper	Herrli
		SF-2	D

- Notes:**
1. THE COPYRIGHT OF THIS DRAWING IS VESTED IN YOURSPEAKERS AND IT MAY NOT BE REPRODUCED IN WHOLE OR PART OR USED FOR THE MANUFACTURE OF ANY ARTICLE WITHOUT THE EXPRESS PERMISSION OF THE COPYRIGHT HOLDERS.
 2. WORK TO FIGURED DIMENSIONS ONLY.
 3. THIS DRAWING IS TO BE READ IN CONJUNCTION WITH ALL RELEVANT AND PREVIOUS DRAWINGS AND TOWNPLANNERS DRAWINGS AND SPECIFICATIONS.

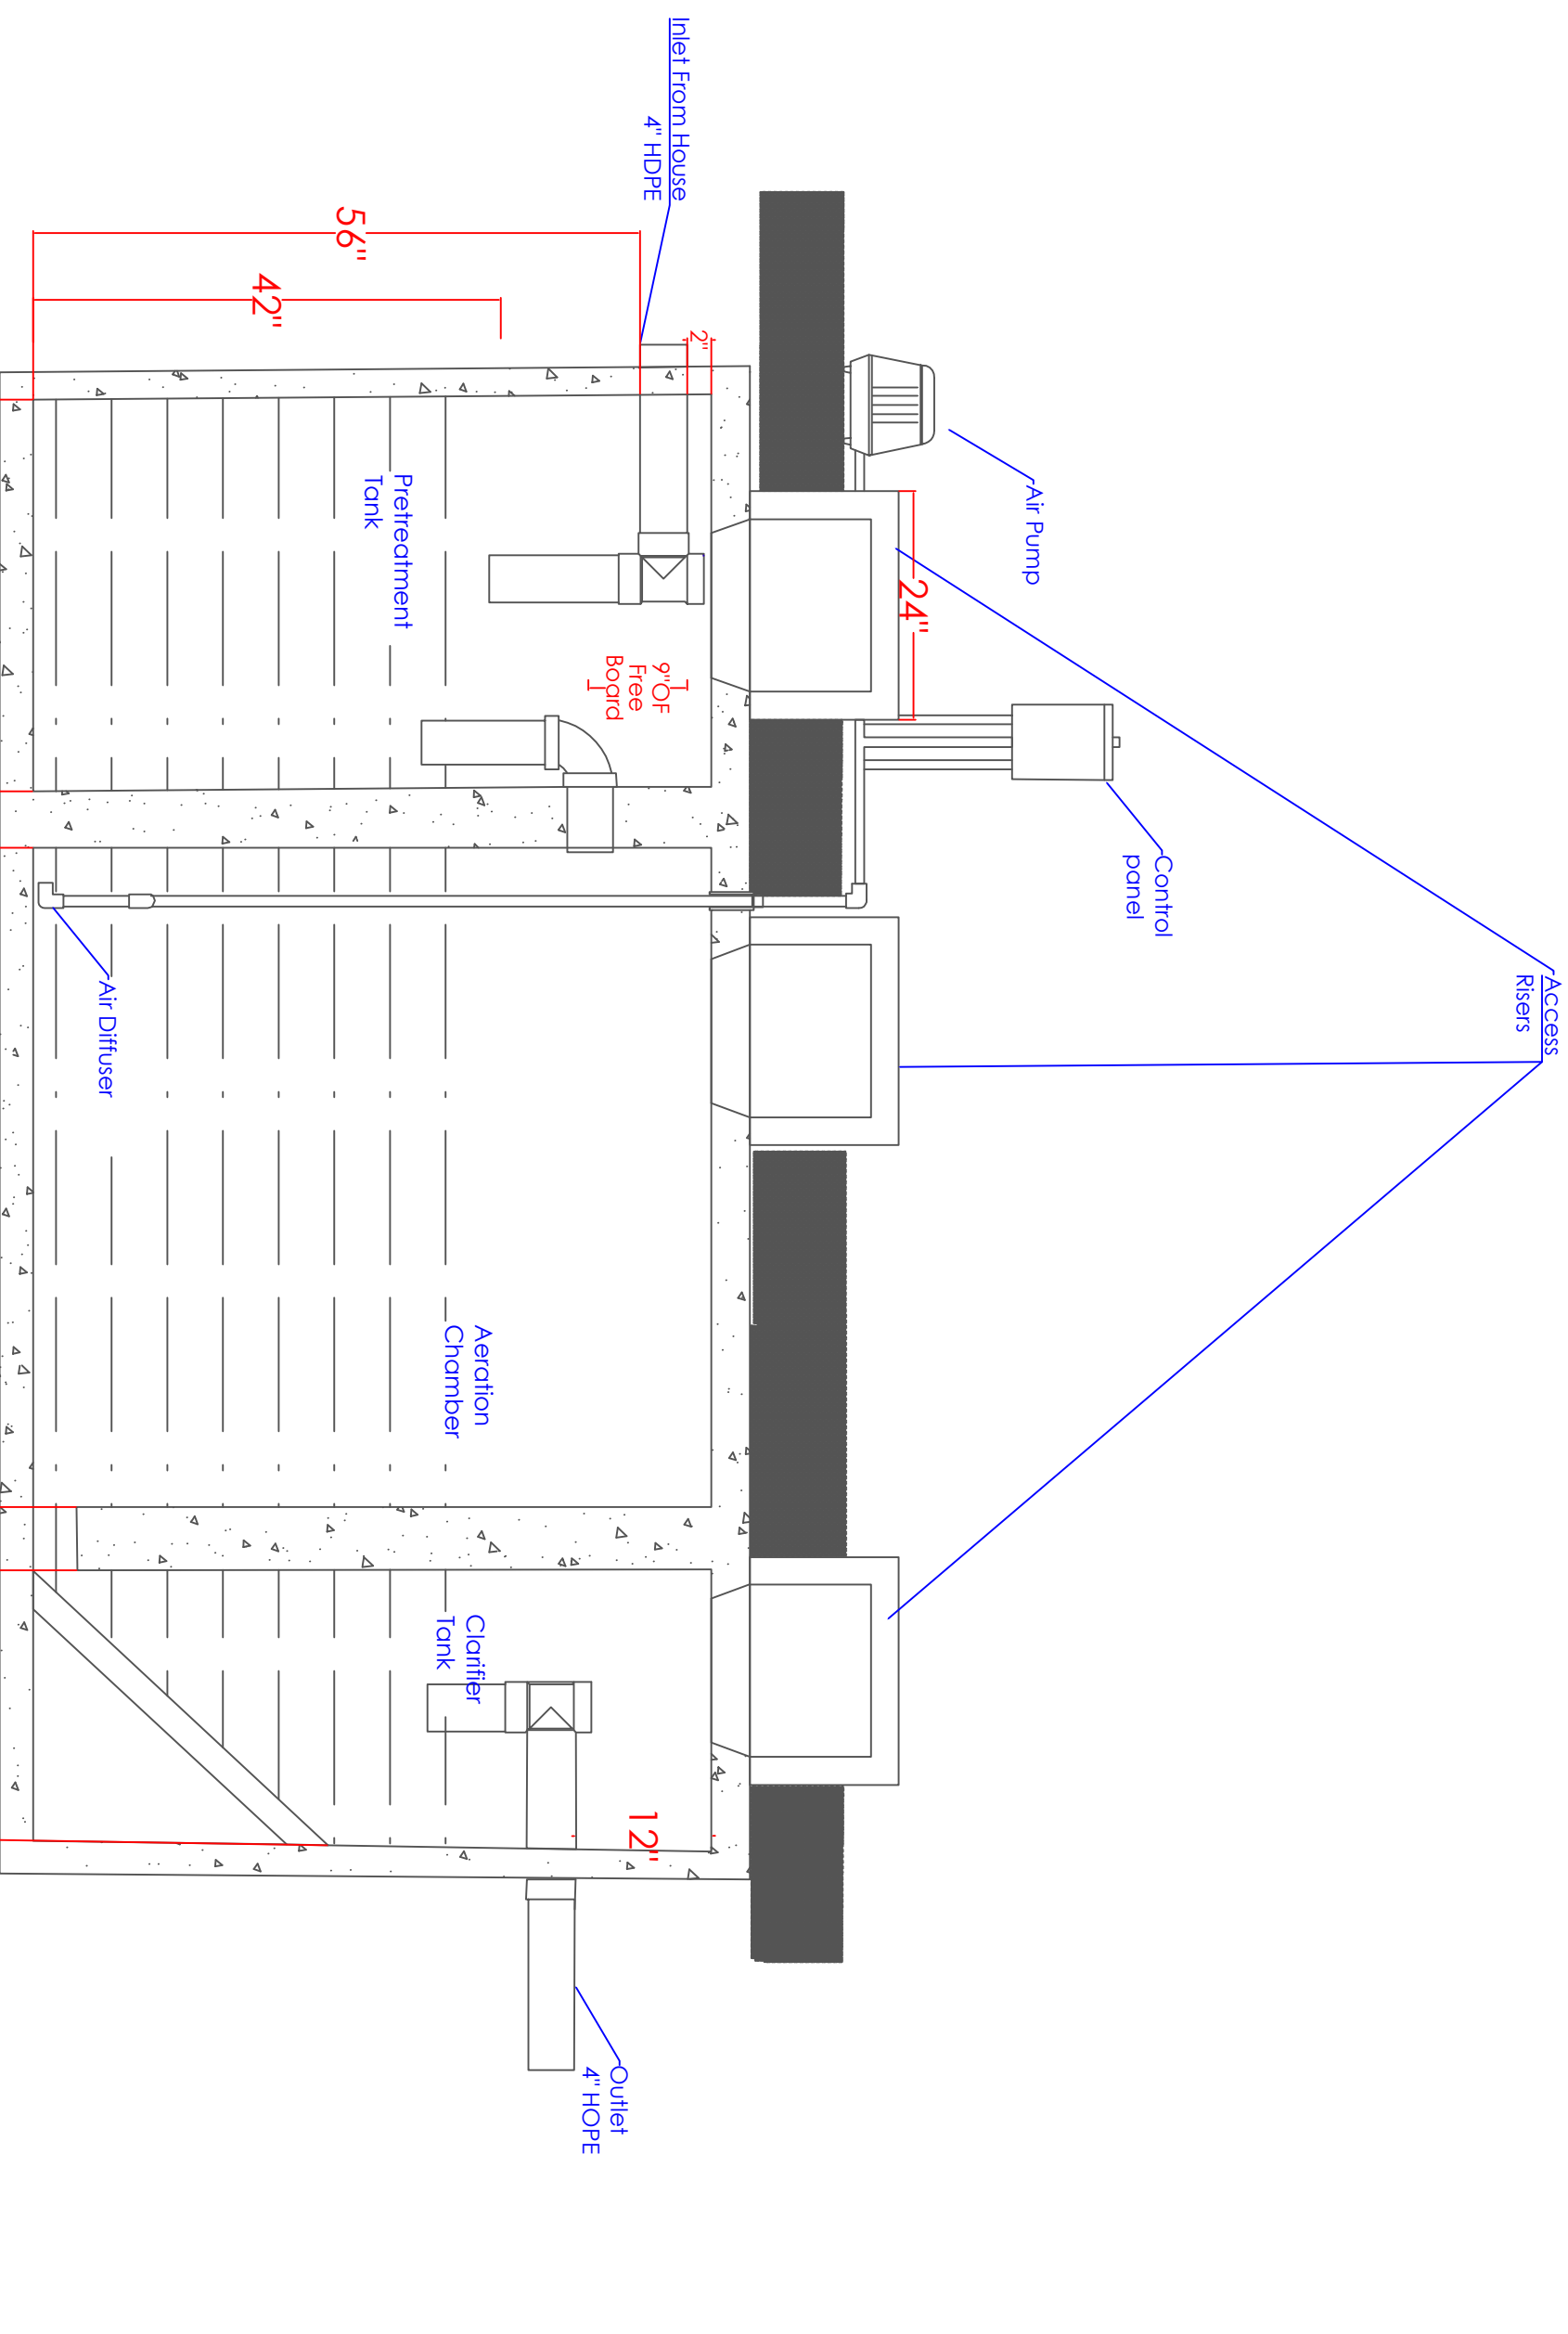

REV.	DESCRIPTION	BY	DATE
	Drawing		

ABCC PROJECTS
 2112 S Huffer Ln
 Flagstaff, AZ 86011
 www.abccprojects.com
 copstone/projects/CENE/
 2022/DeweySeptic/

CLIENT:
 Taylor Layland
 11800 Prescott Delis Ranch Road
 Dewey, AZ

ARCHITECT:
 ABCC Projects
 2112 S Huffer Lane
 Flagstaff, AZ



SITE:
 11800 Prescott Delis
 Ranch Road, Dewey, AZ

TITLE:
 Alternative Septic System
 With Water Reuse

SCALE:	DATE:	DRAWN:	CHECKED:
1:16	12/12/2022	Gilley	Cooper
PROJECT NO:	DRAWING NO:	REVISION:	
001	AS-1	D	

Notes:

 1. THE COPYRIGHT OF THIS DRAWING IS VESTED IN YOURSPEAKERS, AND IT MAY NOT BE REPRODUCED IN WHOLE OR PART OR USED FOR THE MANUFACTURE OF ANY ARTICLE WITHOUT THE EXPRESS PERMISSION OF THE COPYRIGHT HOLDERS.
2. WORK TO FIGURED DIMENSIONS ONLY.
3. THIS DRAWING IS TO BE READ IN CONJUNCTION WITH ALL RELEVANT AND SPECIFICATIONS.

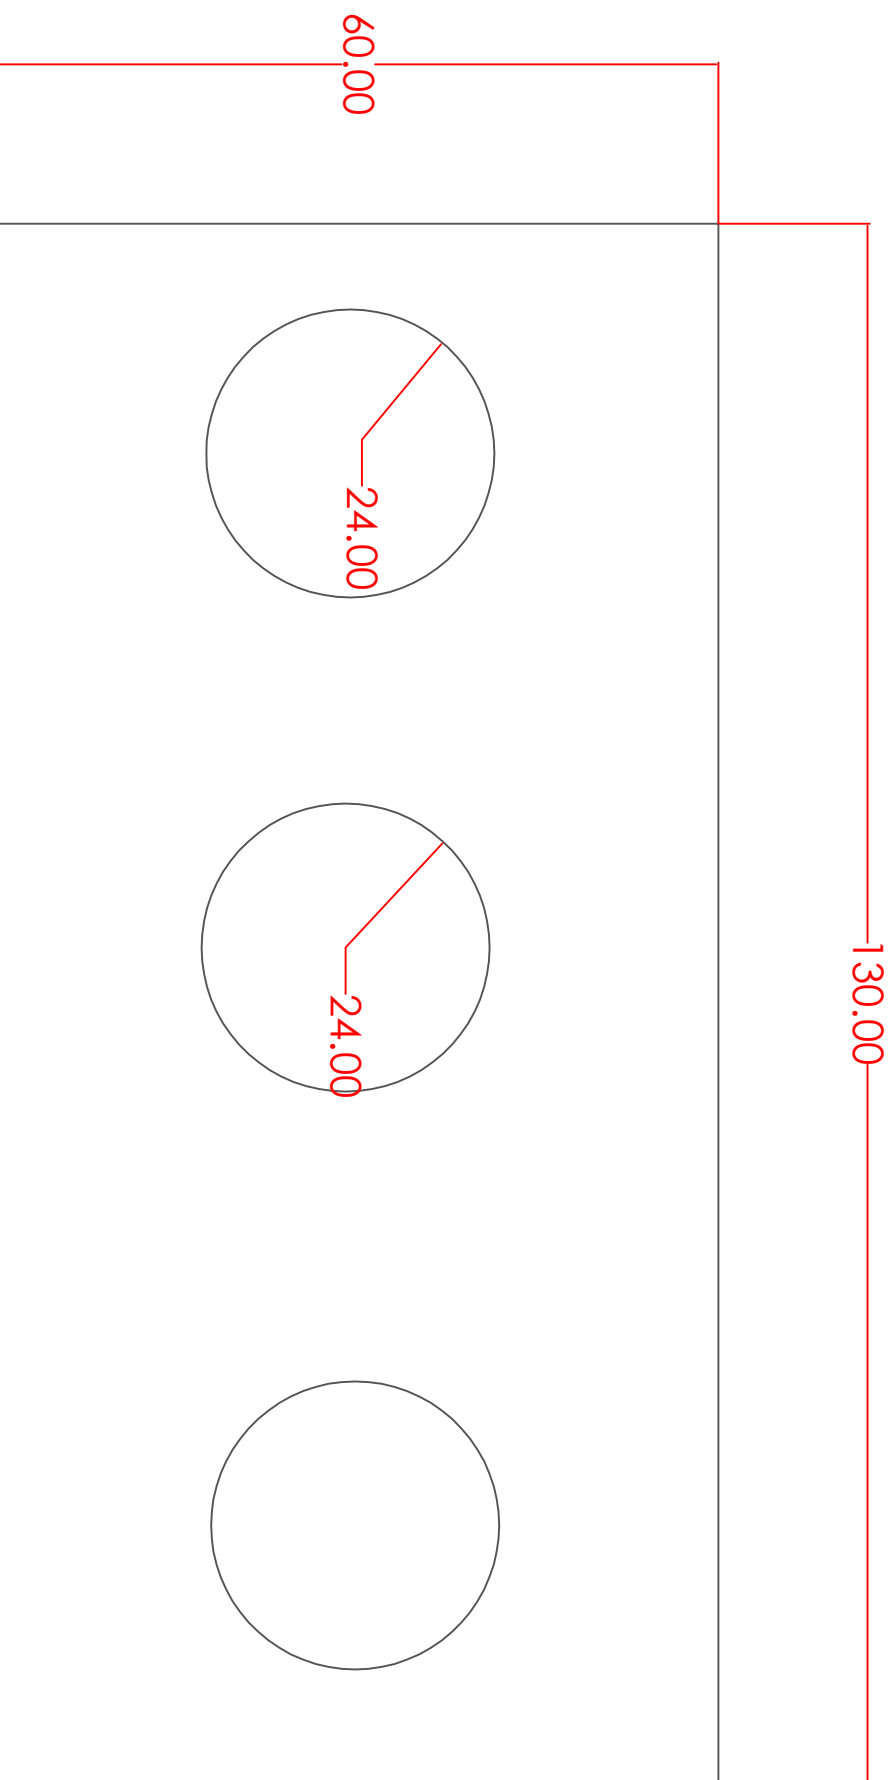

REV.	DESCRIPTION	BY	DATE
	Drawing		

ABCC PROJECTS
 2112 S Huffer Ln
 Flagstaff, AZ 86011
 www.abccaz.com
 copstone/projects/CENR/
 2022/Dewey/septic/

CLIENT:
 Taylor Layland
 11800 Prescott Dells Ranch Road
 Dewey, AZ

ARCHITECT:
 ABCC Projects
 2112 S Huffer Lane
 Flagstaff, AZ

SITE:
 11800 Prescott Dells
 Ranch Road, Dewey, AZ


TITLE:
 Alternative Septic System
 With Water Reuse

SCALE AT ASZ	DATE	DRAWN	CHECKED
1:16	12/12/2022	Gilley	Cooper

PROJECT NO.	DRAWING NO.	REVISION
001	AS-2	D

Notes:

1. THE COPYRIGHT OF THIS DRAWING IS VESTED IN YOURSPEAKERS, AND IT MAY NOT BE REPRODUCED IN WHOLE OR PART OR USED FOR THE MANUFACTURE OF ANY ARTICLE WITHOUT THE EXPRESS PERMISSION OF THE COPYRIGHT HOLDERS.
2. WORK TO FIGURED DIMENSIONS ONLY.
3. THIS DRAWING IS TO BE READ IN CONJUNCTION WITH ALL RELEVANT ABCC'S SERVICE ENGINEERS AND YOURSPEAKERS DRAWINGS AND SPECIFICATIONS.

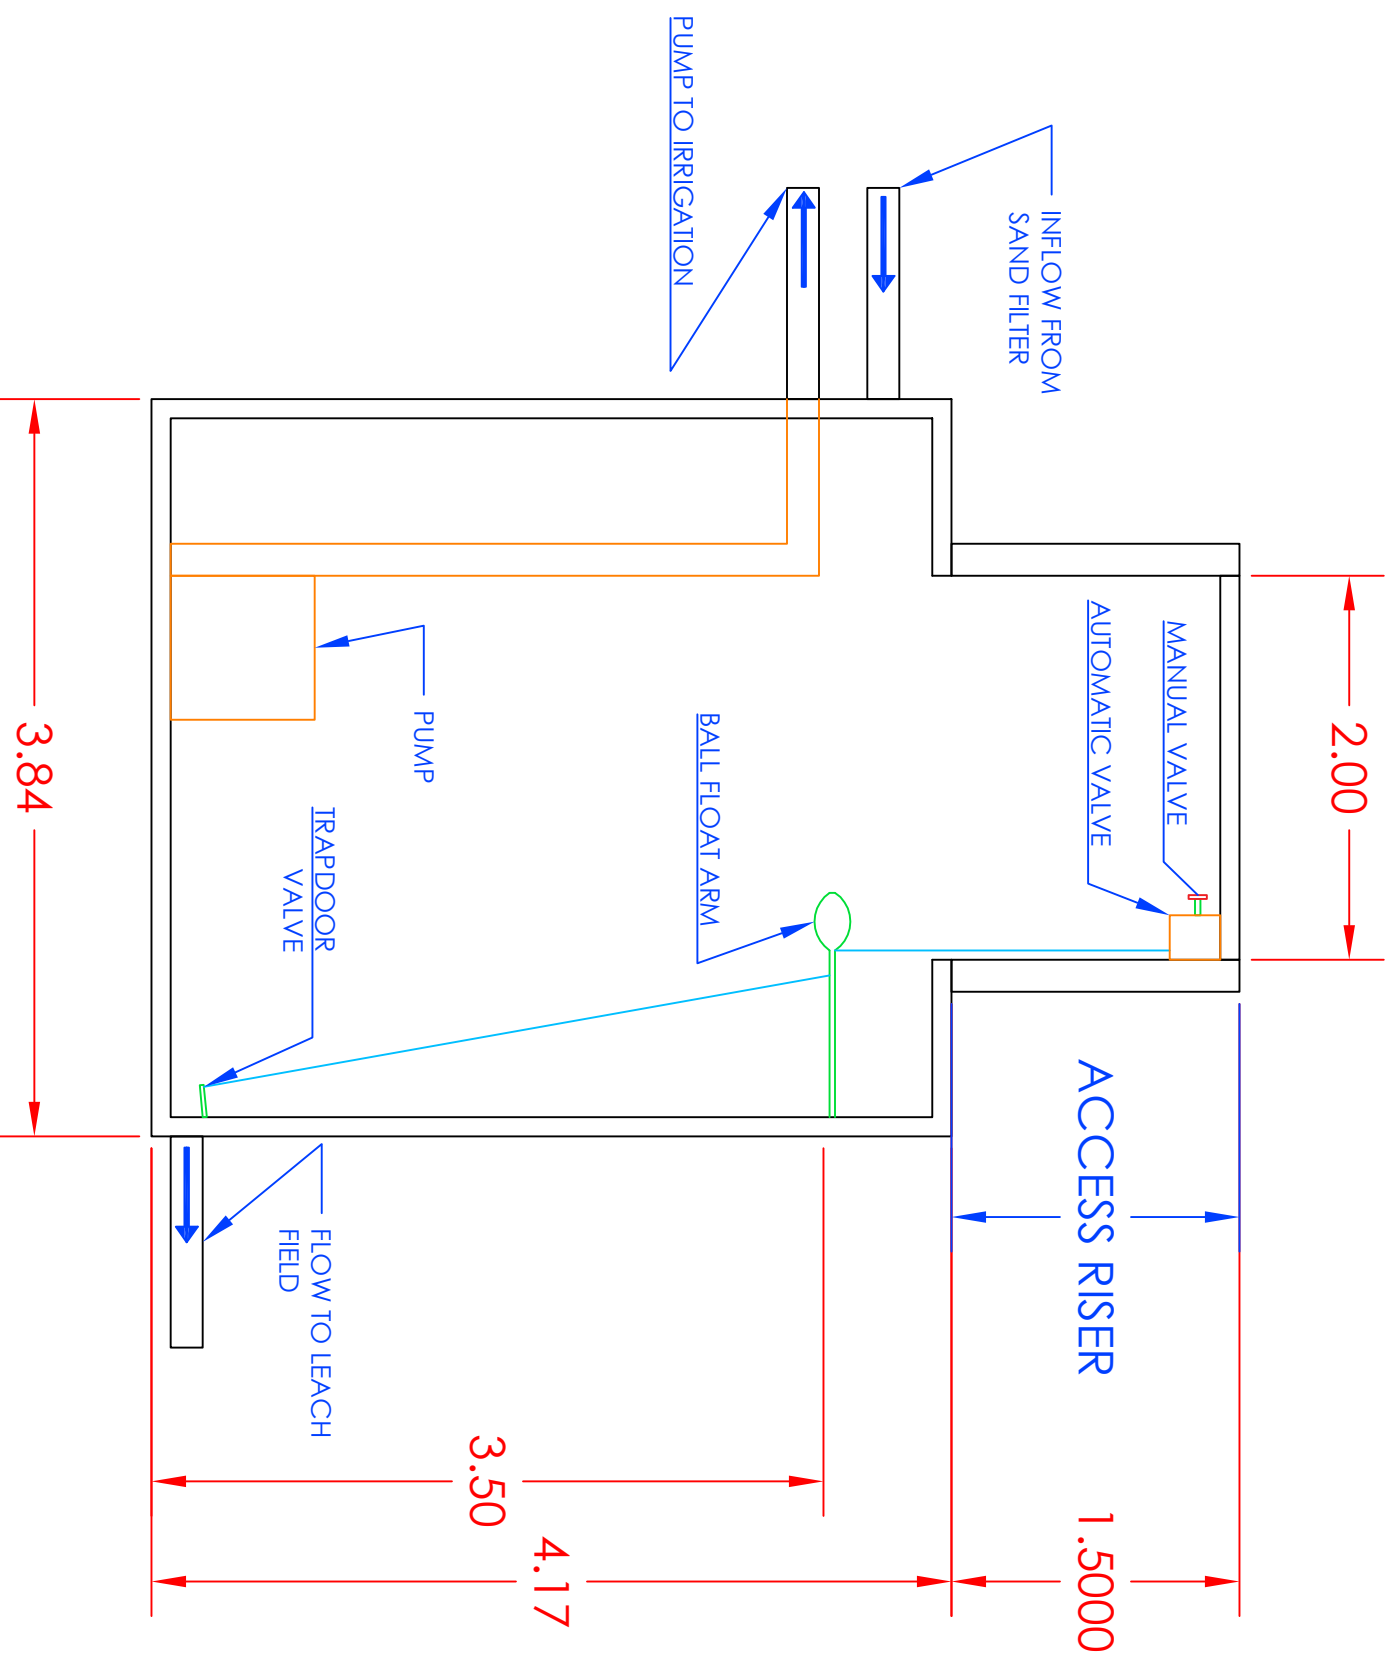

REV.	DESCRIPTION	BY	DATE
	Drawing		

ABCC PROJECTS
 2112 S Huffer Ln
 Flagstaff, AZ 86011
 www.celias.ncsu.edu/
 copstone/projects/CENF/
 2022/Dewey/septic/

CLIENT:
 Taylor Layland
 11800 Prescott Dells Ranch Road
 Dewey, AZ

ARCHITECT:
 ABCC Projects
 2112 S Huffer Lane
 Flagstaff, AZ


SITE:
 11800 Prescott Dells
 Ranch Road, Dewey, AZ

TITLE:
 Alternative Septic System
 With Water Reuse

SCALE AT AGE	DATE	DRAWN	CHECKED
1:1	12/12/2022	Ron	Cooper
PROJECT NO.	DRAWING NO.	REVISION	
001	OF-1	D	

Notes:

1. THE COPYRIGHT OF THIS DRAWING IS VESTED IN YOURSPEAKDESIGNS AND IT MAY NOT BE REPRODUCED IN WHOLE OR PART OR USED FOR THE MANUFACTURE OF ANY ARTICLE WITHOUT THE EXPRESS PERMISSION OF THE COPYRIGHT HOLDERS.
2. WORK TO FIGURED DIMENSIONS ONLY.
3. THIS DRAWING IS TO BE READ IN CONJUNCTION WITH ALL RELEVANT TECHNICAL SPECIFICATIONS AND YOURSPEAKDESIGNS DRAWINGS AND REVISIONS.

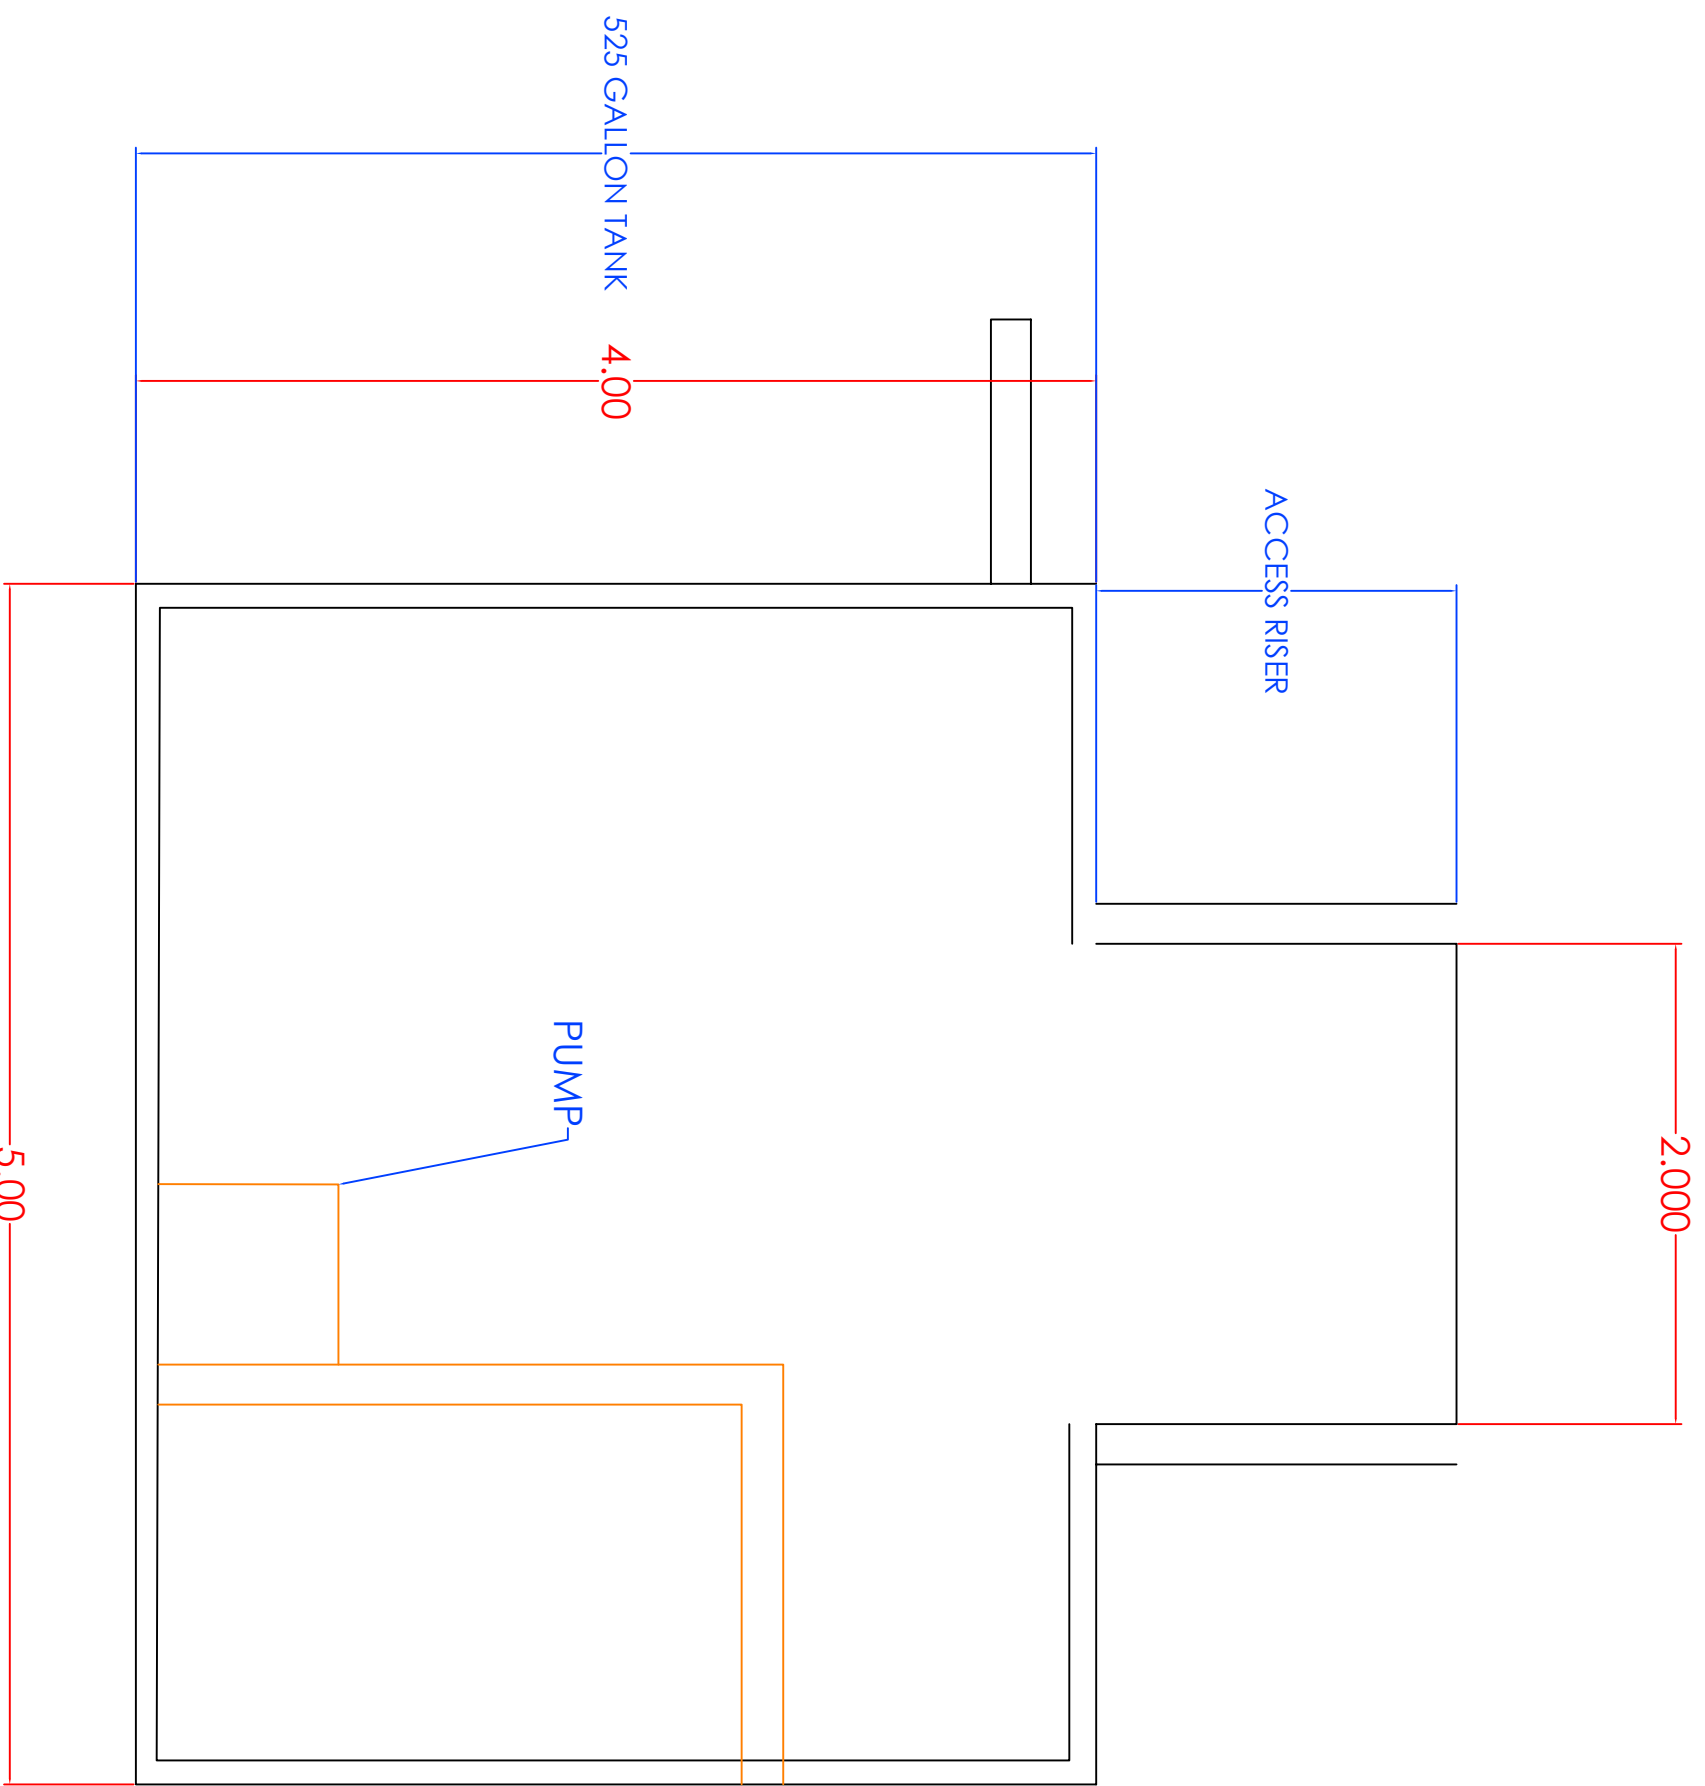

REV.	DESCRIPTION	BY	DATE
	Drawing		

ABCC PROJECTS
 2112 S Huffer Ln
 Flagstaff, AZ 86011
 www.celias.nyu.edu/
 cc@stone/projects/CENE/
 2022/Dewey/Septic/

CLIENT:
 Taylor Loyland
 11800 Prescott Delite Ranch Road
 Dewey, AZ

ARCHITECT:
 ABCC Projects
 2112 S Huffer Lane
 Flagstaff, AZ

SITE:
 11800 Prescott Dells
 Ranch Road, Dewey, AZ


TITLE:
 Alternative Septic System
 With Water Reuse

SCALE AT A2	DATE	DRAWN	CHECKED
1:6	12/12/2022	Cooper	Henri
PROJECT NO:	DRAWING NO:	REVISION:	
001	PT-1		D



Notes:



1. THE COPYRIGHT OF THIS DRAWING IS VESTED IN YOURSPECSHEETZ AND IT MAY NOT BE REPRODUCED IN WHOLE OR PART OR USED FOR THE MANUFACTURE OF ANY ARTICLE WITHOUT THE EXPRESS PERMISSION OF THE COPYRIGHT HOLDERS.
2. WORK TO FIGURED DIMENSIONS ONLY.
3. THIS DRAWING IS TO BE READ IN CONJUNCTION WITH ALL RELEVANT SPECIFICATIONS AND ENGINEERS AND INSPECTORS DRAWINGS AND SPECIFICATIONS.

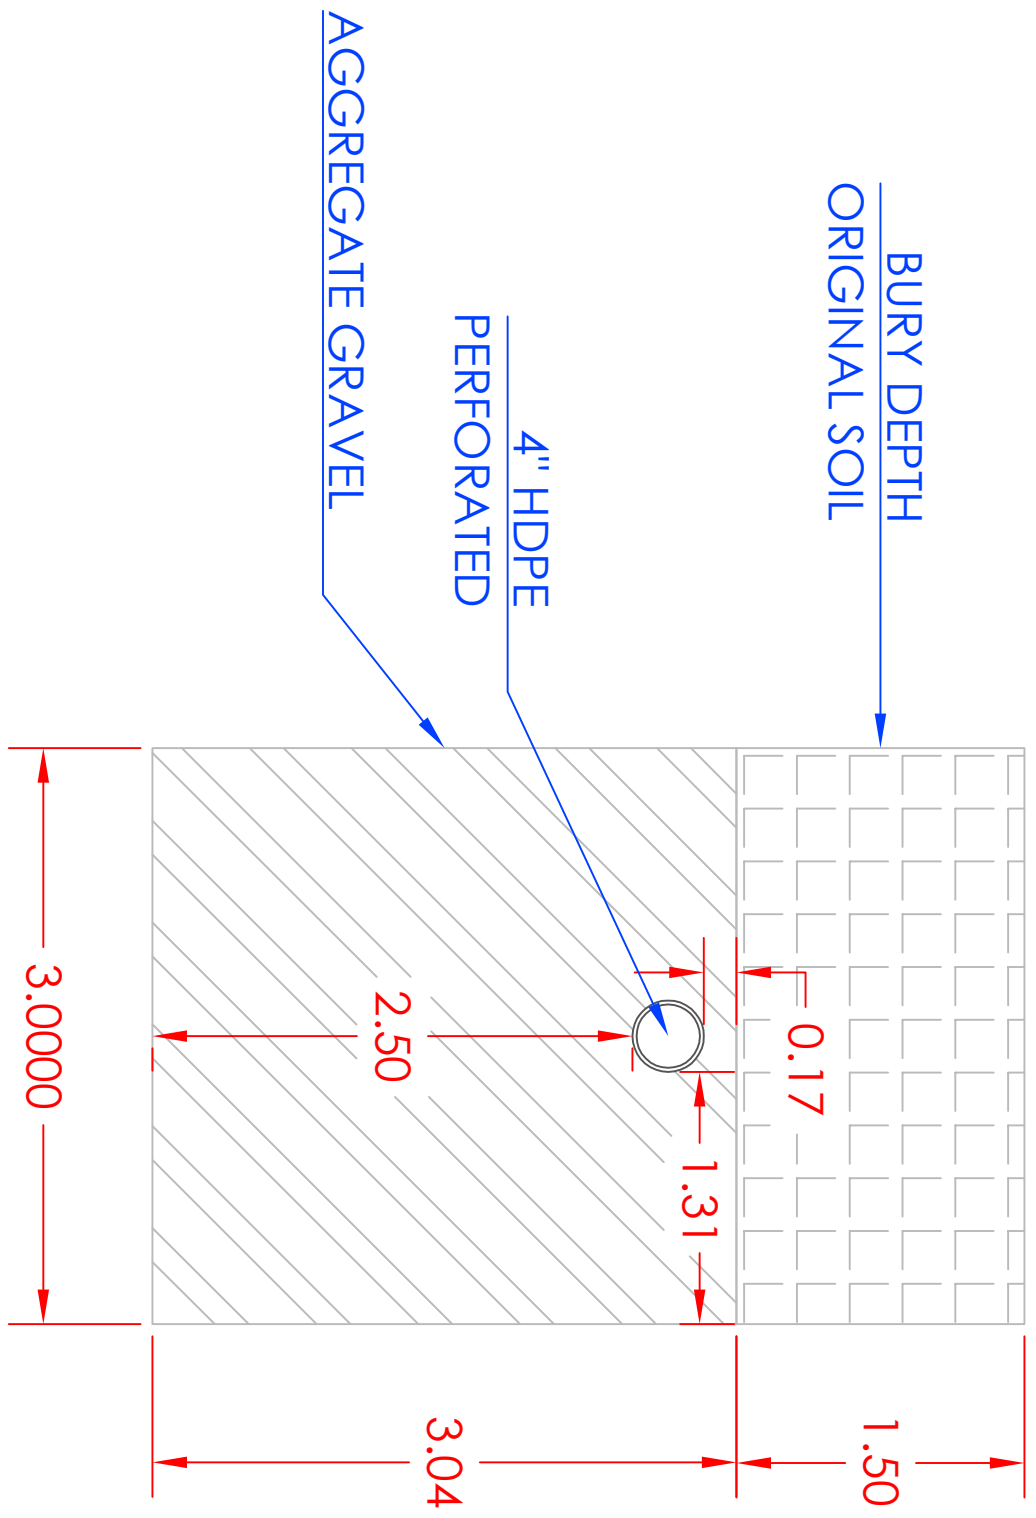

REV:	DESCRIPTION:	BY:	DATE:
	Drawing		
ABCC PROJECTS 2112 S Huffer Ln Flagstaff, AZ 86011 www.abccaz.com ccoptions@projects/abcc/ 2022/DeveySeptic/			
CLIENT:	Taylor Layland 11800 Prescott Delis Ranch Road Dewey, AZ		
ARCHITECT:	ABCC Projects 2112 S Huffer Lane Flagstaff, AZ		
SITE:	11800 Prescott Delis Ranch Road, Dewey, AZ		
TITLE:	Alternative Septic System With Water Reuse		
SCALE AT A2:	DATE:	DRAWN:	CHECKED:
1:1	12/12/2022	Ron	Cooper
PROJECT NO:	DRAWING NO:	REVISION:	
001	LF-1	D	

Notes:

 1. THE COPYRIGHT OF THIS DRAWING IS VESTED IN YOURSPECSHEETZ AND IT MAY NOT BE REPRODUCED IN WHOLE OR PART OR USED FOR THE MANUFACTURE OF ANY ARTICLE WITHOUT THE EXPRESS PERMISSION OF THE COPYRIGHT HOLDERS.
2. WORK TO FIGURED DIMENSIONS ONLY.
3. THIS DRAWING IS TO BE READ IN CONJUNCTION WITH ALL RELEVANT SPECIFICATIONS AND ENGINEERS AND YOURSPECSHEETZ DRAWINGS AND SPECIFICATIONS.

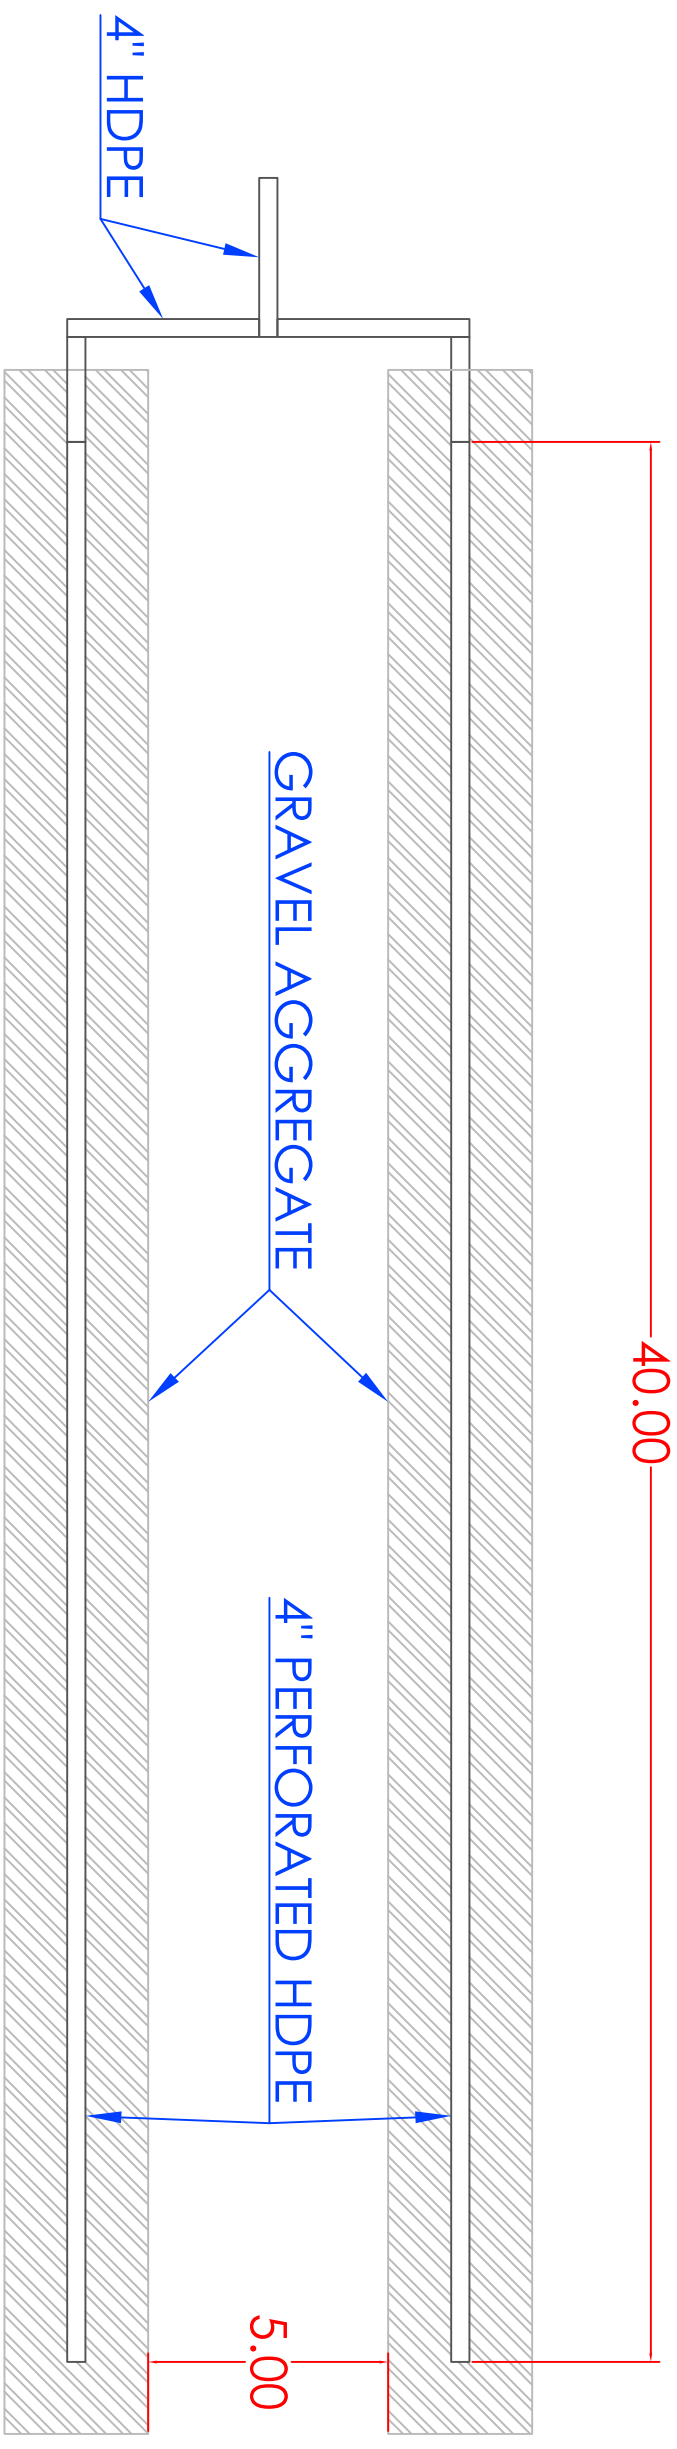


REV.	DESCRIPTION	BY	DATE
	Drawing		

ABCC PROJECTS 2112 S Huffer Ln Flagstaff, AZ 86011 www.abccprojects.com ccoptions@projects.com 2022/DeweySeptic/	
CLIENT:	Taylor Layland 11800 Prescott Delis Ranch Road Dewey, AZ
ARCHITECT:	ABCC Projects 2112 S Huffer Lane Flagstaff, AZ
SITE:	11800 Prescott Delis Ranch Road, Dewey, AZ Alternative Septic System With Water Reuse
SCALE AT A2:	1:4
PROJECT NO:	001
DATE:	12/12/2022
DRAWN:	Ron
CHECKED:	Cooper
REVISION:	D

Notes:

1. THE COPYRIGHT OF THIS DRAWING IS VESTED IN YOURSPEEDHEADS AND IT MAY NOT BE REPRODUCED IN WHOLE OR PART OR USED FOR THE MANUFACTURE OF ANY ARTICLE WITHOUT THE EXPRESS PERMISSION OF THE COPYRIGHT HOLDERS.
2. WORK TO FIGURED DIMENSIONS ONLY.
3. THIS DRAWING IS TO BE READ IN CONJUNCTION WITH ALL RELEVANT SPECIFICATIONS AND TENDERS AND YOURSPEEDHEADS DRAWINGS AND SPECIFICATIONS.

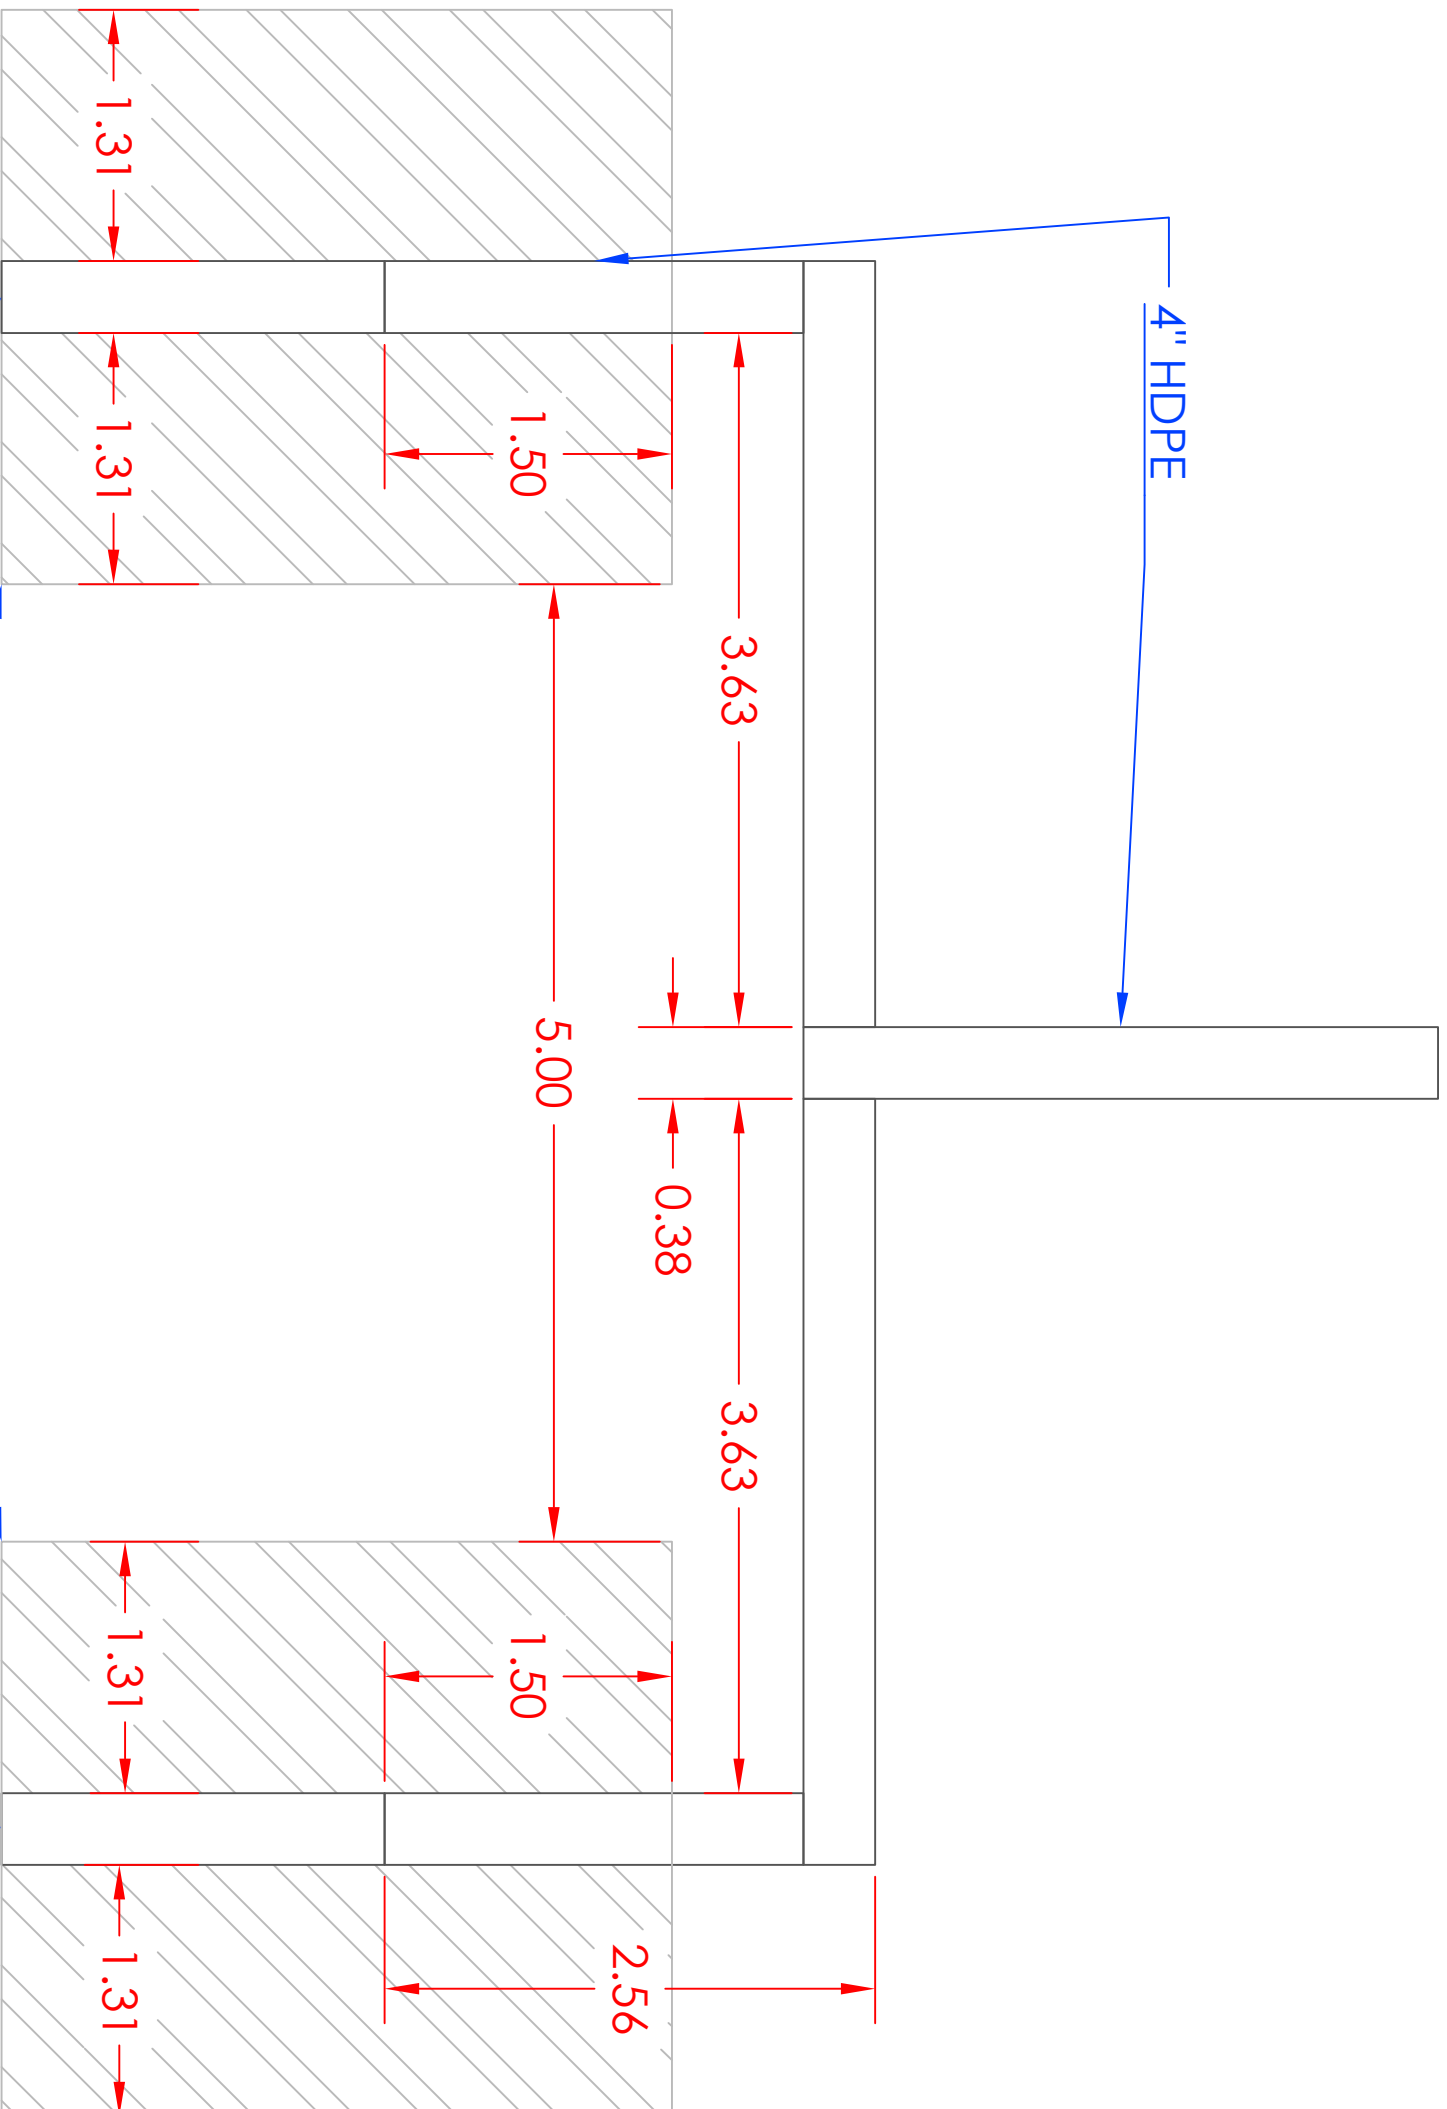

4" HDPE
GRAVEL
PERFORATED TO LEACH FIELD
4" HDPE



REV#	DESCRIPTION:	BY:	DATE:
	Drawing		
<p>ABCC PROJECTS 2112 S Huffer Ln Flagstaff, AZ 86011 www.abccprojects.com ccc@abccprojects.com 2022/DeweySeptic/</p>			
CLIENT:	<p>Taylor Layland 11800 Prescott Delis Ranch Road Dewey, AZ</p>		
ARCHITECT:	<p>ABCC Projects 2112 S Huffer Lane Flagstaff, AZ</p>		
SITE:	<p>11800 Prescott Delis Ranch Road, Dewey, AZ</p>		
TITLE:	<p>Alternative Septic System With Water Reuse</p>		
SCALE AT A2:	DATE:	DRAWN:	CHECKED:
1:1	12/12/2022	Ron	Cooper
PROJECT NO:	DRAWING NO:	REVISION:	
001	LF-3	D	